


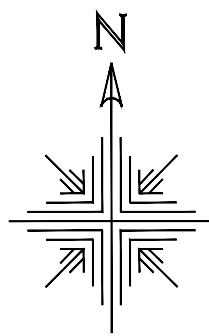



CALL BEFORE YOU DIG!  
At least 72 hours prior to commencement of the work, the Contractor is responsible for calling the Utilities Protection Center (UPC) at 1-800-282-7411, to request underground utility locate service.




BRUNSWICK-GLYNN COUNTY  
JOINT WATER & SEWER COMMISSION  
PLANNING & CONSTRUCTION DIVISION  
1703 Gloucester Street  
Brunswick, Georgia 31520  
(912) 261-7110 Phone  
(912) 261-7175 Fax  
www.bglwsc.org

| NO. | DATE | COMMENTS |
|-----|------|----------|
|     |      |          |
|     |      |          |
PS4116  
REHABILITATION AND FM UPGRADE  
GLYNN COUNTY, GEORGIA  
BRUNSWICK-GLYNN COUNTY JOINT WATER & SEWER COMMISSION


|                    |
|--------------------|
| FILE NO.: PS4116   |
| DATE: DEC 21, 2020 |
| SCALE: AS SHOWN    |
| DRAWN BY: HJP      |

SHEET NO.:  
**P-1**  
OF 8

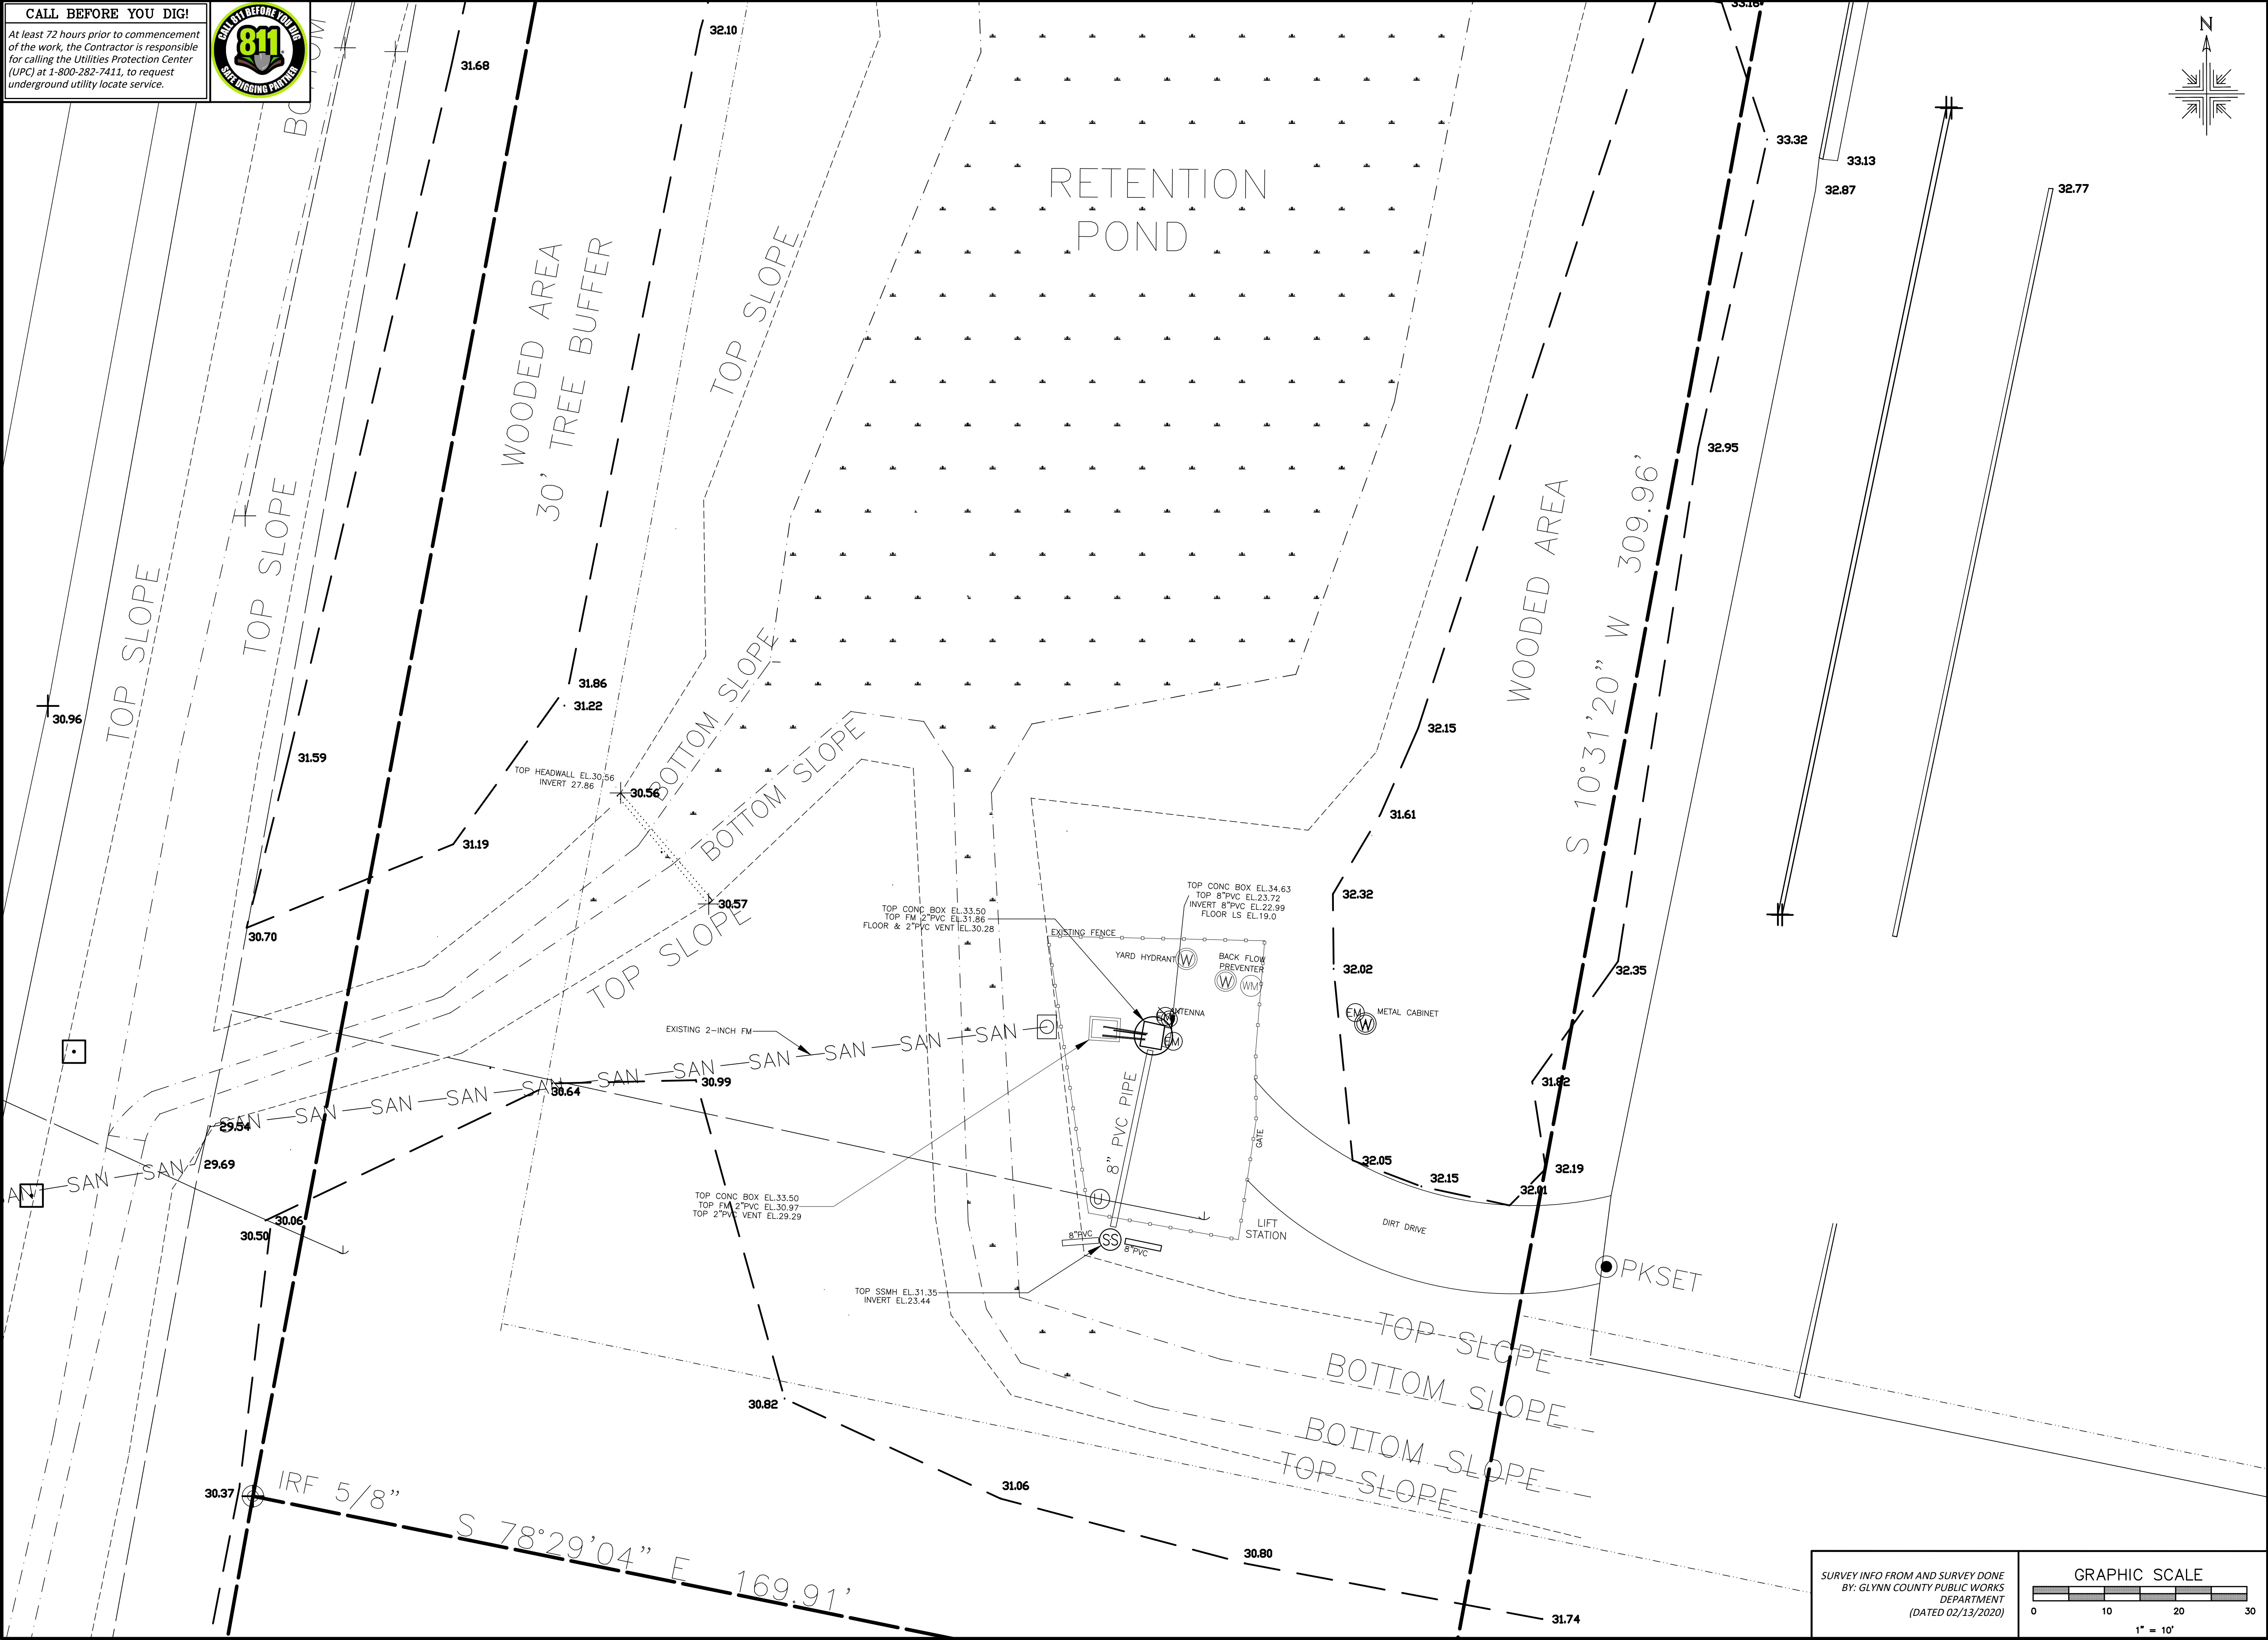

SURVEY INFO FROM AND SURVEY DONE  
BY: GLYNN COUNTY PUBLIC WORKS  
DEPARTMENT  
(DATED 02/13/2020)

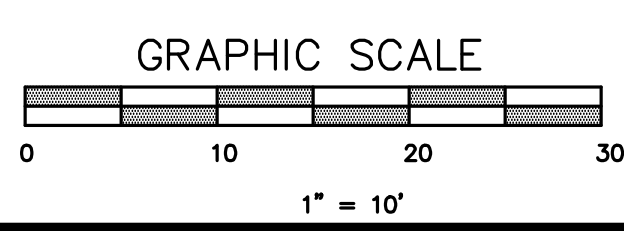

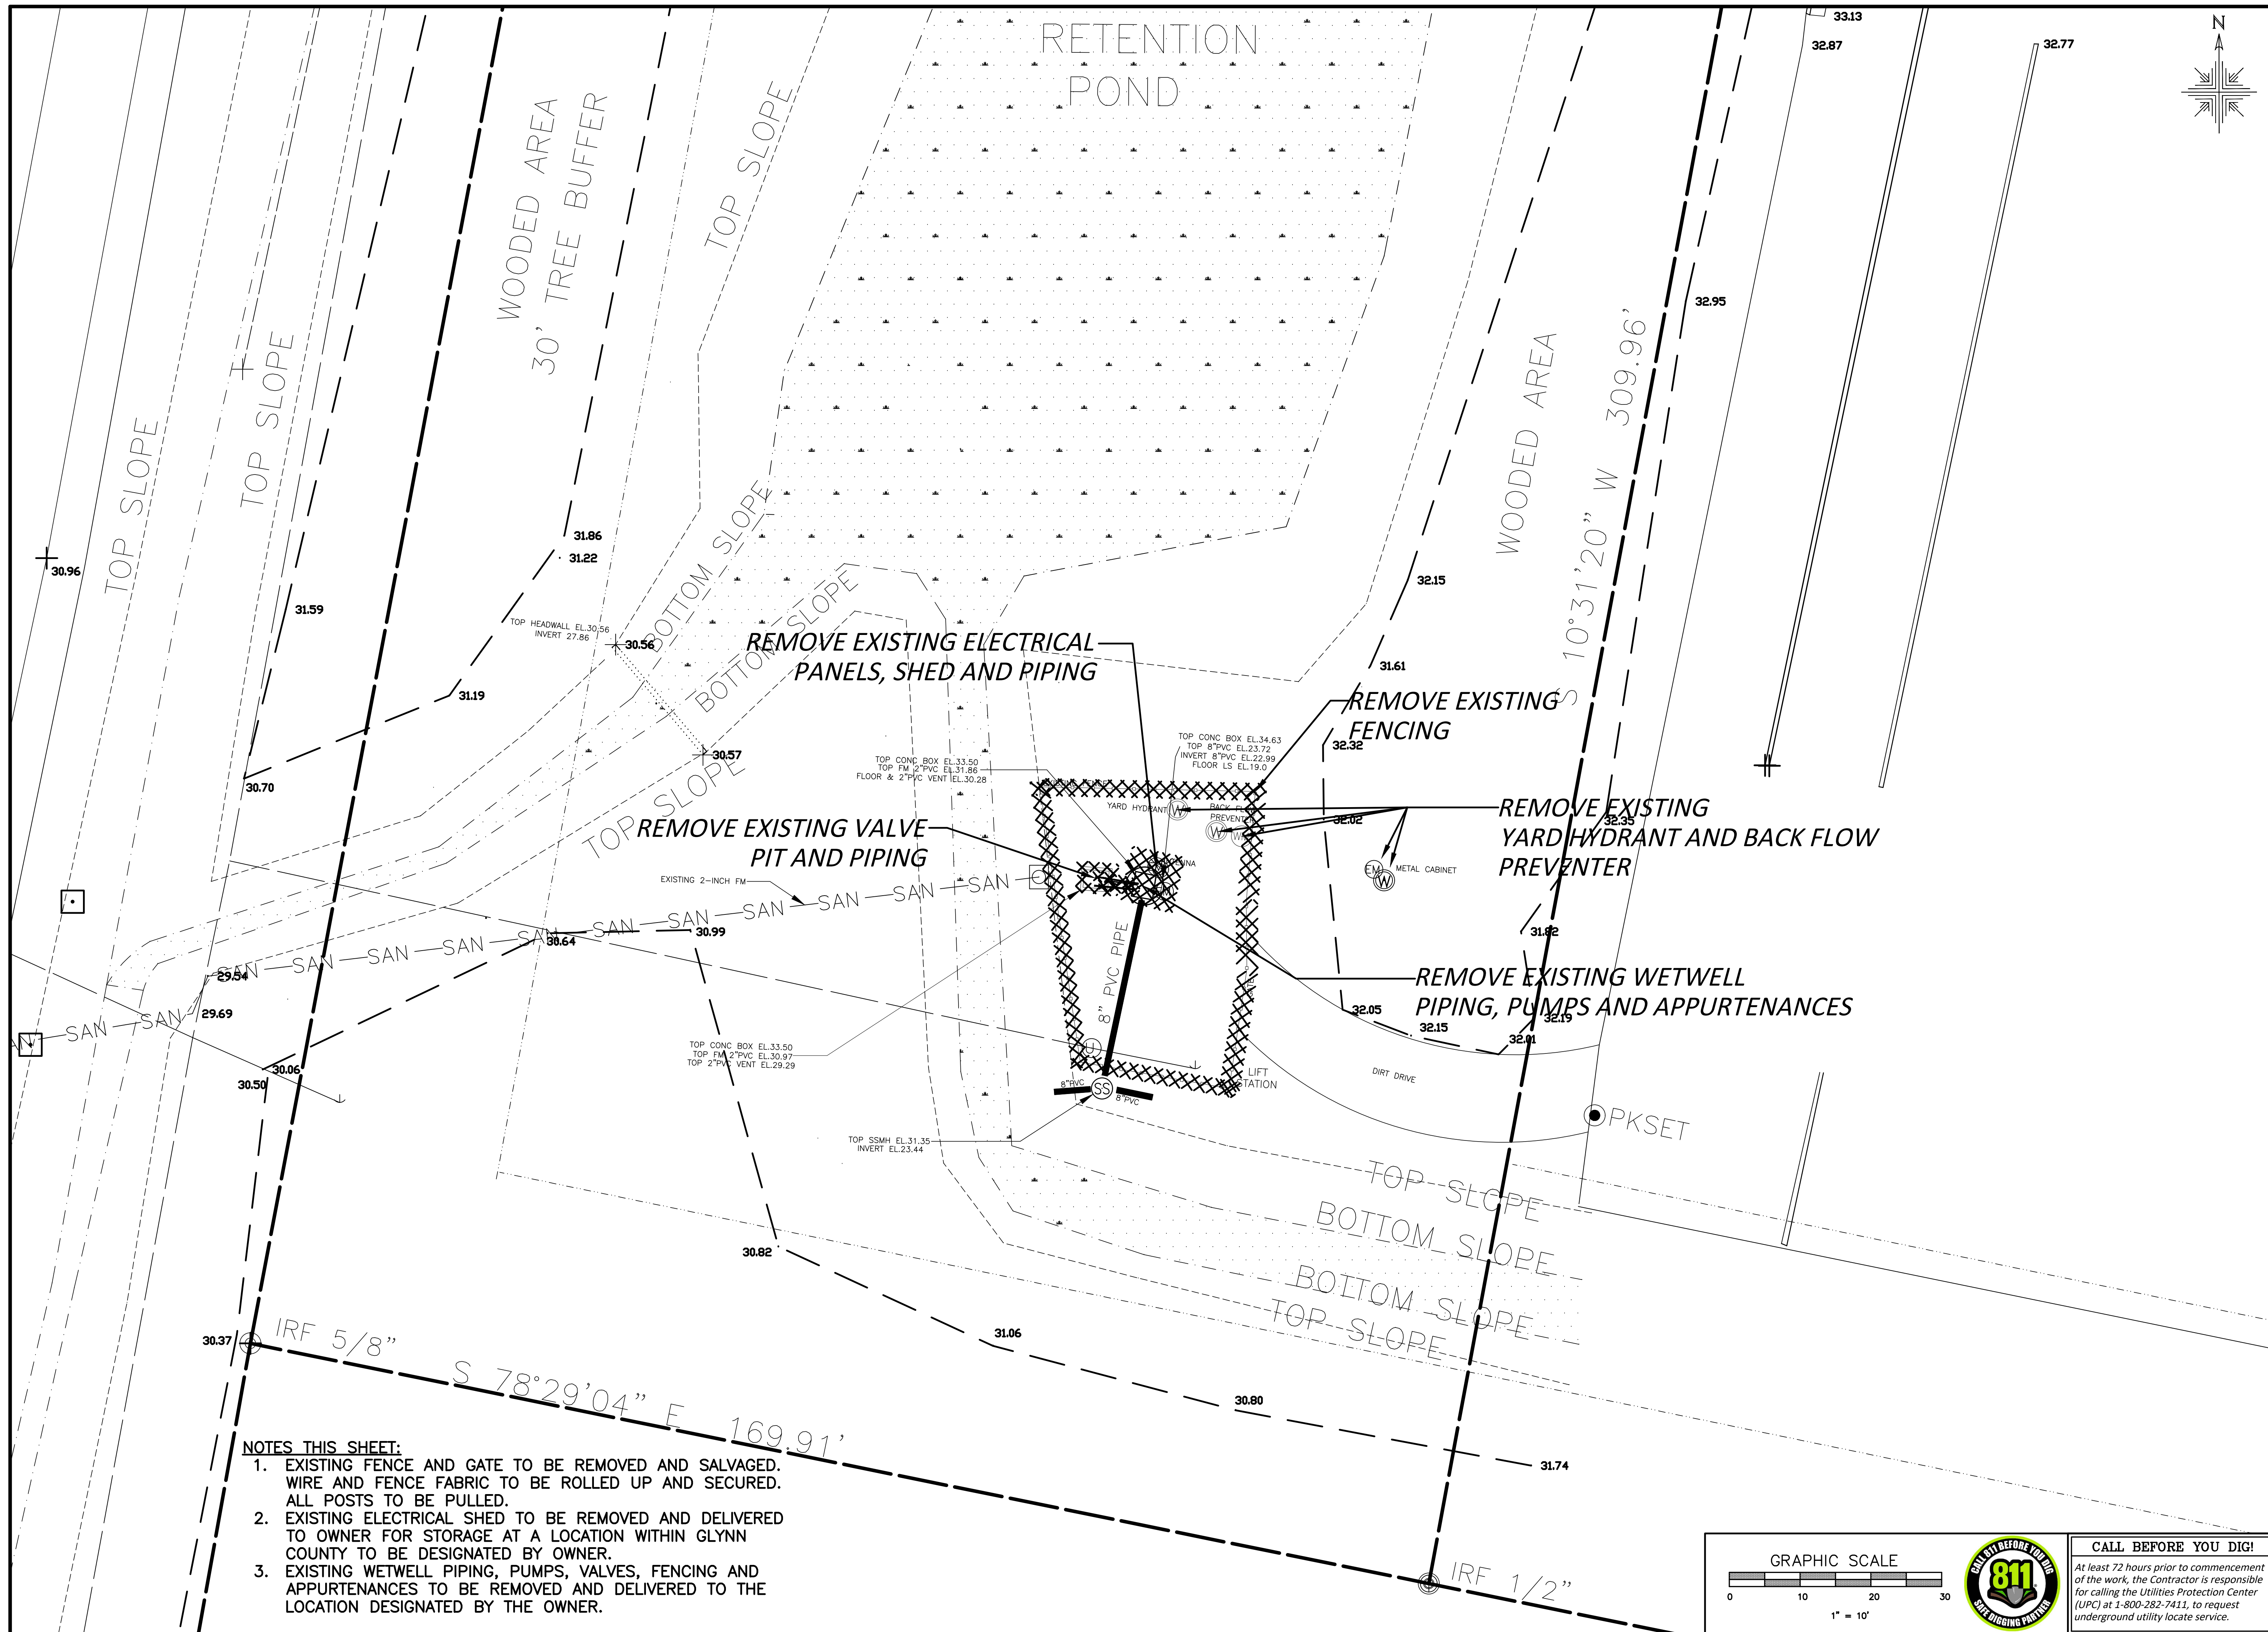

- NOTES THIS SHEET:**
1. EXISTING FENCE AND GATE TO BE REMOVED AND SALVAGED. WIRE AND FENCE FABRIC TO BE ROLLED UP AND SECURED. ALL POSTS TO BE PULLED.
  2. EXISTING ELECTRICAL SHED TO BE REMOVED AND DELIVERED TO OWNER FOR STORAGE AT A LOCATION WITHIN GLYNN COUNTY TO BE DESIGNATED BY OWNER.
  3. EXISTING WETWELL PIPING, PUMPS, VALVES, FENCING AND APPURTENANCES TO BE REMOVED AND DELIVERED TO THE LOCATION DESIGNATED BY THE OWNER.

GRAPHIC SCALE

**CALL BEFORE YOU DIG!**

At least 72 hours prior to commencement of the work, the Contractor is responsible for calling the Utilities Protection Center (UPC) at 1-800-282-7411, to request underground utility locate service.

BRUNSWICK-GLYNN COUNTY  
JOINT WATER & SEWER COMMISSION  
PLANNING & CONSTRUCTION DIVISION

1703 Gloucester Street  
Brunswick, Georgia 31520  
(912) 261-7110 Phone  
(912) 261-7178 Fax  
www.bjgwsoc.org

| NO. | DATE | COMMENTS |
|-----|------|----------|
|     |      |          |
|     |      |          |
|     |      |          |
|     |      |          |
|     |      |          |

PS4116  
REHABILITATION AND FM UPGRADE  
GLYNN COUNTY, GEORGIA

BRUNSWICK-GLYNN COUNTY JOINT WATER & SEWER COMMISSION

DEMOLITION PLAN

FILE NO.: PS4116  
DATE: DEC 21, 2020  
SCALE: AS SHOWN  
DRAWN BY: HTP

SHEET NO.: **P-2**



SITE REQUIREMENTS:

FENCING SHALL BE 6--FEET HIGH CONSISTING OF 2--INCH MESH BY 9 GAUGE ALUMINUM COATED STEEL FABRIC WITH BLACK PVC COATING. THE FENCE SHALL HAVE A 7 GAUGE ALUMINUM COATED STEEL COIL SPRING TENSION WIRE ALONG THE BOTTOM OF THE FENCE FABRIC AND 3 STRANDS OF 12--1/2 GAUGE ALUMINUM COATED STEEL BARBED WIRE ALONG THE TOP OF THE FENCE FABRIC. FENCE POSTS SHALL BE AS FOLLOWS:

- CORNER POSTS -- 3 INCH OD GALVANIZED
- LINE POSTS -- 2--1/2 INCH OD GALVANIZED

CORNER AND GATE POSTS SHALL HAVE NECESSARY STRUTS AND TIE BRACING WITH WATER TIGHT CLOSURE CAPS. GATE SHALL CONSIST OF A DOUBLE 8'-0" LONG 6'-0" HIGH SECTIONS AND SHALL BE EQUIPPED WITH A LATCH AND HASP ASSEMBLY. A GROUND ANCHOR CAST IN CONCRETE SHALL BE INSTALLED.

CONTROLS SHALL BE DESIGNATED TO AUTOMATICALLY TO OPERATE PUMPS IN RESPONSE TO EXCURSIONS IN LIQUID LEVEL AS SPECIFIED FOR THE STATION. CONTROL PANEL SHALL BE UL 508A CERTIFIED AND LISTED, COMPLETELY ASSEMBLED, WIRED, TESTED AND PROPERLY LABELED PRIOR TO SHIPMENT. CONTROL PANEL TO BE REUSED FROM SITE BY PREFERRED INTEGRATOR TO ENSURE COMPATIBILITY BETWEEN PUMPS AND CONTROLS.

THE PUMP CONTROLS SHALL BE HOUSED IN A NEMA 4X STAINLESS STEEL ENCLOSURE WITH 3PT PAD LOCKABLE LATCH AND ALUMINUM INNER DOOR. THE INNER DOOR SHALL BE 12 GAUGE WITH A 0.75--INCH 90 DEGREE BREAK ON ALL 4 SIDES. WIRING SHALL HAVE NO LESS THAN 600 VOLT INSULATION WITH A 75° CELSIUS RATING. THE ENCLOSURE SHALL BE ADEQUATELY SIZED TO PROVIDE PROPER SPACING OF THE EQUIPMENT AND HAVE A PROPERLY SIZED COOLING SYSTEM IF REQUIRED. AIR CONDITIONING WHERE APPLICABLE, OR HEAT EXCHANGER WHEN APPROVED BY JWSC.

ELECTRICAL CONTROLS SHALL BE CONTROLLED BY JWSC'S STANDARD SCADA PUMP CONTROLLER AS MANUFACTURED BY ELECTRIC MACHINE CONTROL, INC. (205--661--3998 TRUSSVILLE, ALABAMA)

THE PANEL SHALL CONSIST OF THE FOLLOWING COMPONENTS (APPROVED MANUFACTURERS AS LISTED IN SECTION 4 OF THE JWSC'S STANDARD FOR WATER AND SEWER CONSTRUCTION SHALL BE USED) :

- HAND--OFF--AUTOMATIC SWITCH FOR EACH PUMP
- OVERLOAD AND SHORT CIRCUIT PROTECTION FOR EACH PUMP
- CONTROL POWER BREAKER
- GFCI OUTLET ON DEADFRONT OF MCC
- GFCI BREAKER
- 24 VOLT CONTROLS
- RED STROBE HIGH LEVEL ALARM LIGHT
- MOTOR PROTECTION CIRCUITS FOR OVER AND UNDER CURRENT/VOLTAGE AND PHASE CHANGE
- CIRCUIT BREAKER FOR EACH PUMP WITH INNER DOOR LOCK WHEN IN "ON" POSITION
- FIELD WIRING CONNECTION USING TERMINAL STRIPS WITH SEPARATE BLOCKS FOR PUMP, SCADA CONTROL AND SCADA ALARMS
- PUMP STARTING SHALL USE NEMA RATED VFD DRIVES
- RTAC 3505 INSIDE THE SCADA PANEL FOR VFD BYPASS PUMP AND MMR CONTROL
- PUMP SEAL LEAD DETECTION AND MOTOR THERMAL MONITOR RELAY BY THE PUMP MANUFACTURER
- PUMP SEAL FAILURE AMBER WARNING PILOT LIGHT ON MCC
- PUMP THERMAL FAIL RED WARNING PILOT LIGHT ON MCC
- GREEN PUMP RUNNING PILOT LIGHTS ON MCC
- PILOT LIGHTS SHALL BE LED FOR LONG LIFE
- BREAKERS, PILOT LIGHTS, AND SWITCHES SHALL BE OIL TIGHT MOUNTED ON INNER DOOR FOR OPERATOR ACCESS
- RUN TIME HOUR METERS
- SEL MMR 849 RELAY FOR MOTOR/PHASE LOSS PROTECTION
- ALARM HORN WITH SILENCE BUTTON
- ALL MOUNTING SCREWS SHALL BE STAINLESS MACHINE WITH BACKPLATE HOLES DRILLED AND TAPPED
- EQUIPMENT SHED LIGHTING SHALL BE (4) LITHONIA DMS232120 OR APPROVED EQUAL SECURED TO SHELTER STRUCTURE WITH 0 DEGREE F RATED ELECTRONIC BALLAST.



GENERAL CONSTRUCTION NOTES:

- CONTRACTOR SHALL COORDINATE AND SCHEDULE WITH THE OWNER (JWSC) ANY SYSTEM SHUTDOWNS NECESSARY FOR THE CONSTRUCTION OF THE PROPOSED IMPROVEMENTS.
- THE CONTRACTOR SHALL COORDINATE ALL WORK WITH THE OWNER. JOINT WATER & SEWER COMMISSION CONTACT TODD KLINE, P.E. AT 912-261-7122.
- CONTRACTOR SHALL PROVIDE AND MAINTAIN BY--PASS PUMPING DURING THE ENTIRE CONSTRUCTION PERIOD. THE CONTRACTOR SHALL PREPARE & SUBMIT A BY--PASS PLAN TO THE ENGINEER AND/OR THE JWSC FOR REVIEW AND APPROVAL.
- ALL WORK TO BE PERFORMED THAT IS NOT DEFINED BY THE CONTRACT DOCUMENTS SHALL BE CONSTRUCTED IN ACCORDANCE WITH STATE, COUNTY AND/OR LOCAL CODES.
- CONTRACTOR TO PROVIDE AND MAINTAIN ALL NECESSARY BARRICADES, SUFFICIENT LIGHTING, SIGNS AND OTHER TRAFFIC CONTROL METHODS AS MAY BE NECESSARY FOR THE PROTECTION AND SAFETY OF THE PUBLIC SHALL BE PROVIDED AND MAINTAINED THROUGHOUT THE DURATION OF THE OF THE PROPOSED CONSTRUCTION IMPROVEMENTS.
- THE UTILITIES SHOWN ARE FOR THE CONTRACTORS CONVENIENCE ONLY. THERE MAY BE UTILITIES OTHER THAN THOSE SHOWN ON THESE PLANS. THE OWNER AND ENGINEER ASSUME NO RESPONSIBILITY FOR THE LOCATIONS SHOWN AND IS SHALL BE THE CONTRACTORS RESPONSIBILITY TO VERIFY THE LOCATIONS OF ALL UTILITIES WITHIN THE LIMITS OF WORK. DAMAGES MADE TO EXISTING UTILITIES BY THE CONTRACTOR SHALL BE THE SOLE RESPONSIBILITY OF THE CONTRACTOR AND SHALL BE REPAIRED AT NO EXPENSE TO THE OWNER.
- CONTRACTOR SHALL VERIFY THE LOCATION OF ALL EXISTING UTILITIES PRIOR TO EXCAVATION. CONTRACTOR SHALL NOTIFY ALL UTILITY OWNER AT LEAST 72 HOURS PRIOR TO CONSTRUCTION (811 OR 800-282-7411). ANY CONFLICTS SHALL BE IMMEDIATELY REPORTED TO THE OWNER.
- CONTRACTOR SHALL NOTIFY USING AGENCY AT LEAST 72 HOURS IN ADVANCE IF ANY UTILITY SERVICE (E.G. WATER, SEWER, GAS, POWER, TELEPHONE, ETC.) IS TO BE TEMPORARILY INTERRUPTED IN ORDER TO CONSTRUCT IMPROVEMENTS.
- CONTRACTOR IS RESPONSIBLE FOR ALL REQUIRED STATE & LOCAL PERMITTING FOR CONSTRUCTION.
- EXISTING DISCHARGE PIPING & VALVING TO BE REMOVED AND DELIVERED TO JWSC.
- CONTRACTOR TO SANDBLAST ALL METAL SURFACES TO WHITE CONDITION (BARE, CLEAN METAL) & RE--COAT PER SPECIFICATIONS.
- ALL FLANGED DUCTILE IRON PIPE AND FITTINGS TO BE FIELD PAINTED IN ACCORDANCE WITH JWSC STANDARDS AND SHALL BE INTERNALLY LINED WITH PROTECTO 401 SEWER SAFE LINING FOR RAW SEWAGE APPLICATIONS. ANY DUCTILE IRON PIPE AND FITTINGS INSIDE THE WET WELL SHALL RECEIVE TWO COATS OF COAL TAR EPOXY (TNEMEC SERIES 46-46, TNEMECOLOR OR APPROVED EQUAL).
- ALL BURIED DI FITTINGS SHALL BE MECHANICAL JOINT WITH MEGA-LUG JOINT RESTRAINTS.
- ALL METALLIC FASTENERS & HARDWARE TO BE 316 STAINLESS STEEL.
- USE LINK-SEAL ON ALL VAULT PENETRATIONS.
- COORDINATE WITH JWSC WATER DISTRIBUTION DIVISION FOR RELOCATION OF EXISTING WATER SERVICE(S).
- COORDINATE WITH GA POWER FOR RELOCATION OF EXISTING POWER POLE(S).

SITE REQUIREMENTS:


THE ENTIRE SITE AND ACCESS ROAD SHALL BE COVERED WITH A GEOTEXTILE FILTER FABRIC COVERED WITH 6 INCHES OF #57 STONE. STONE SHALL BE CLEAN WITH NO SOIL OR FOREIGN MATTER PRESENT AND SHALL BE CONTAINED WITHIN 2X6 PRESSURE TREATED BORDER BOARDS. TREAT GRAVELED AREA WIT A HIGH QUALITY, LONG LASTING, EPA ENVIRONMENTALLY APPROVED WEED KILLER.

YARD LIGHT TO BE POLE MOUNTED 120V 500W QUARTZ AREA LIGHT WITH A MINIMUM MOUNTING HEIGHT OF 12 FEET ABOVE FINISHED GRADE. FIXTURE SHALL BE LITHONIA CAT# F500QL-120-M12 OR APPROVED EQUAL.

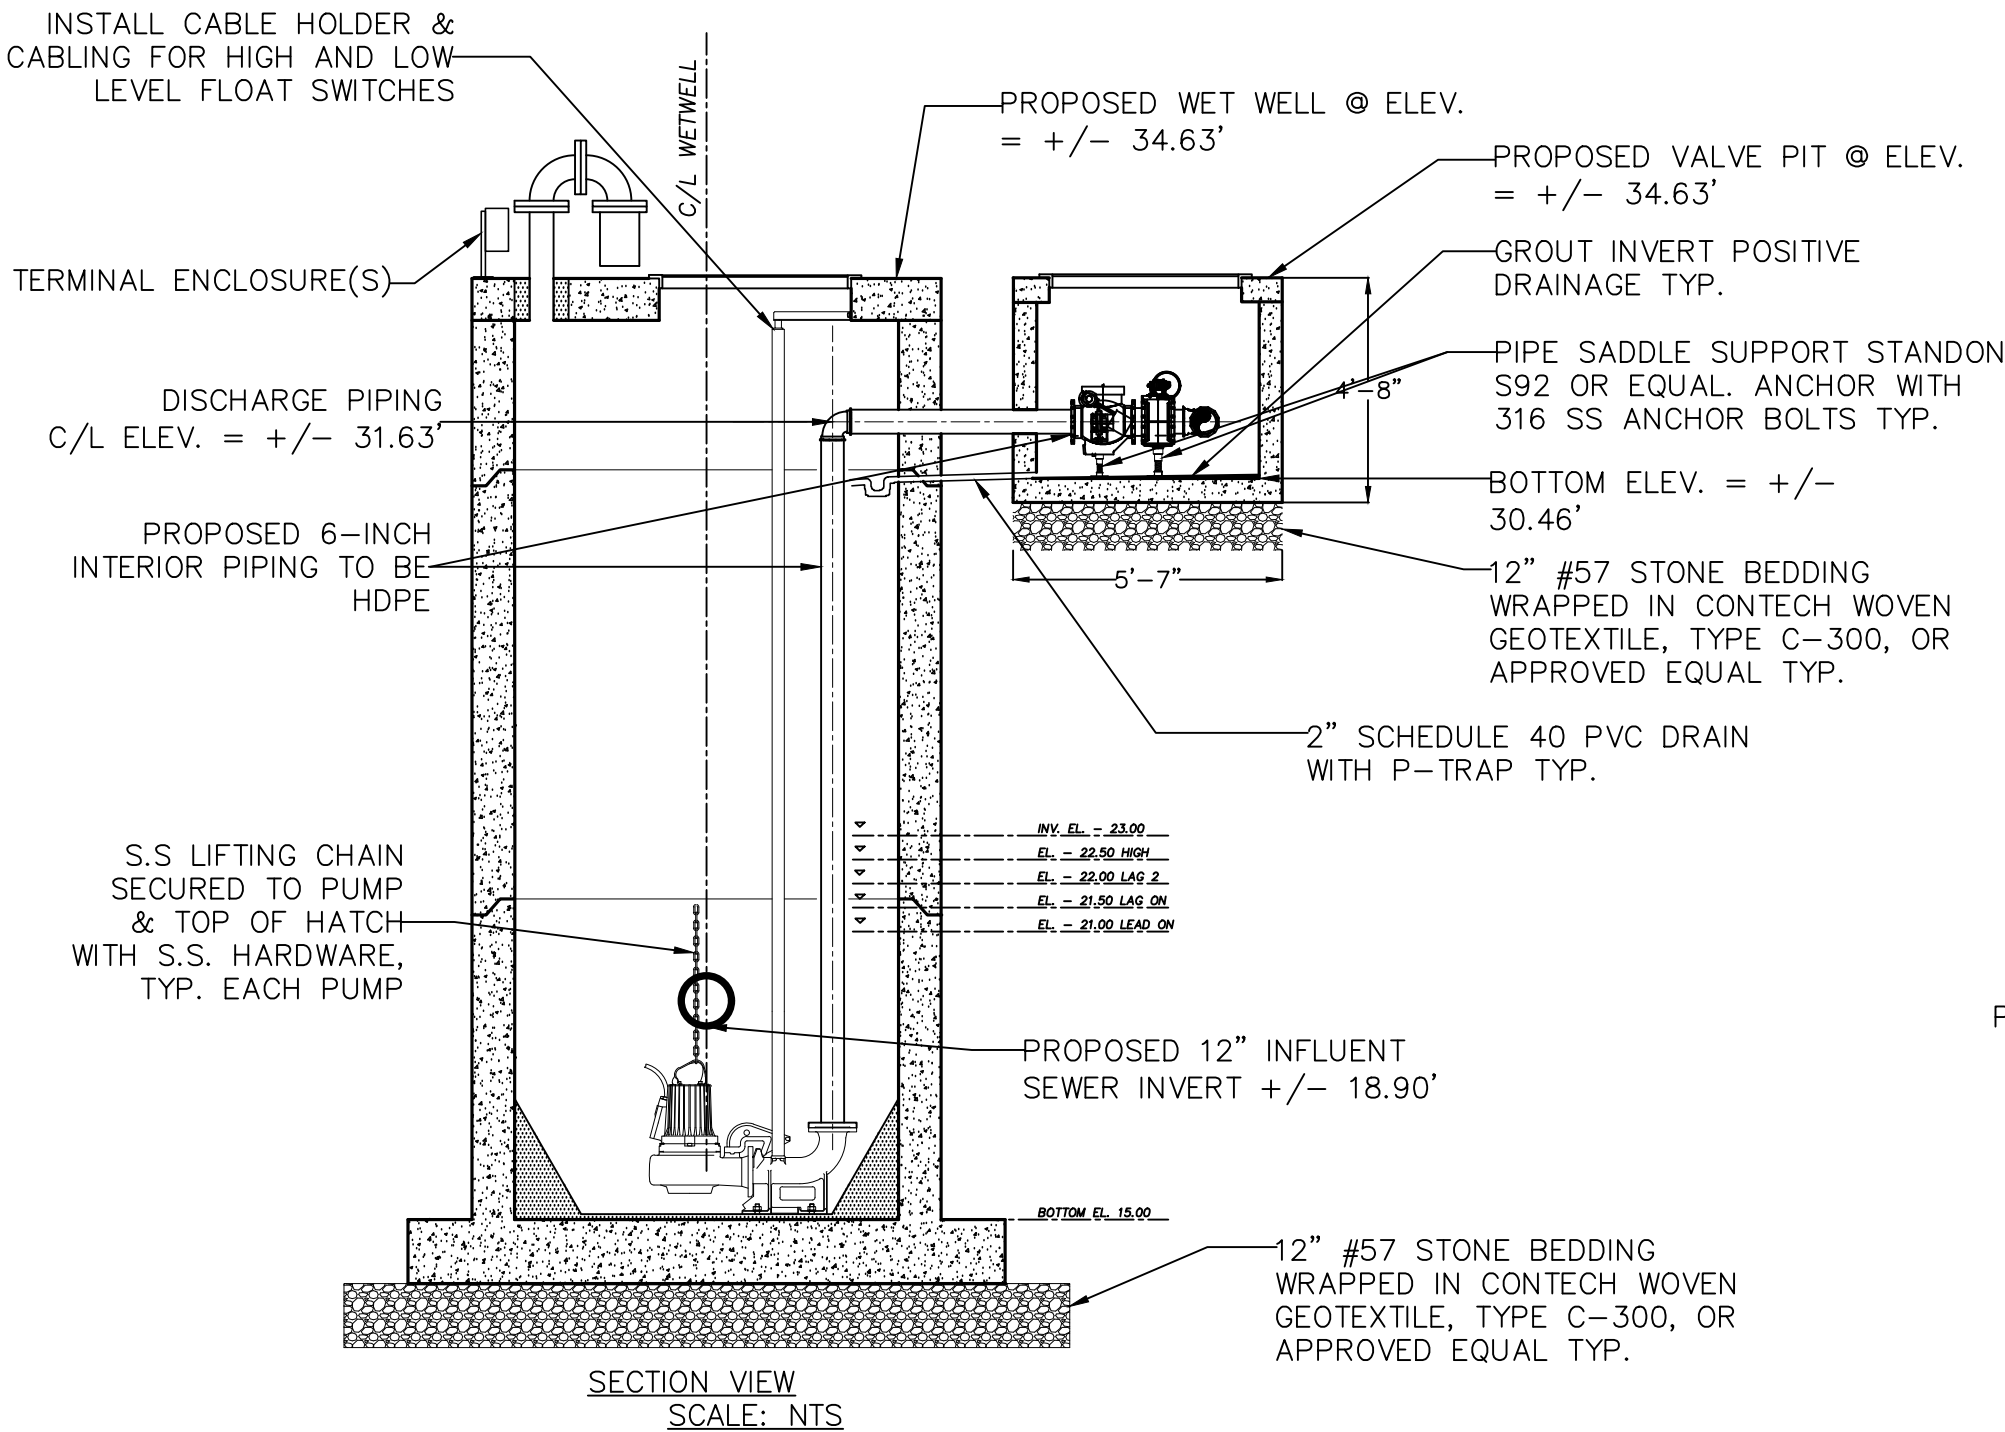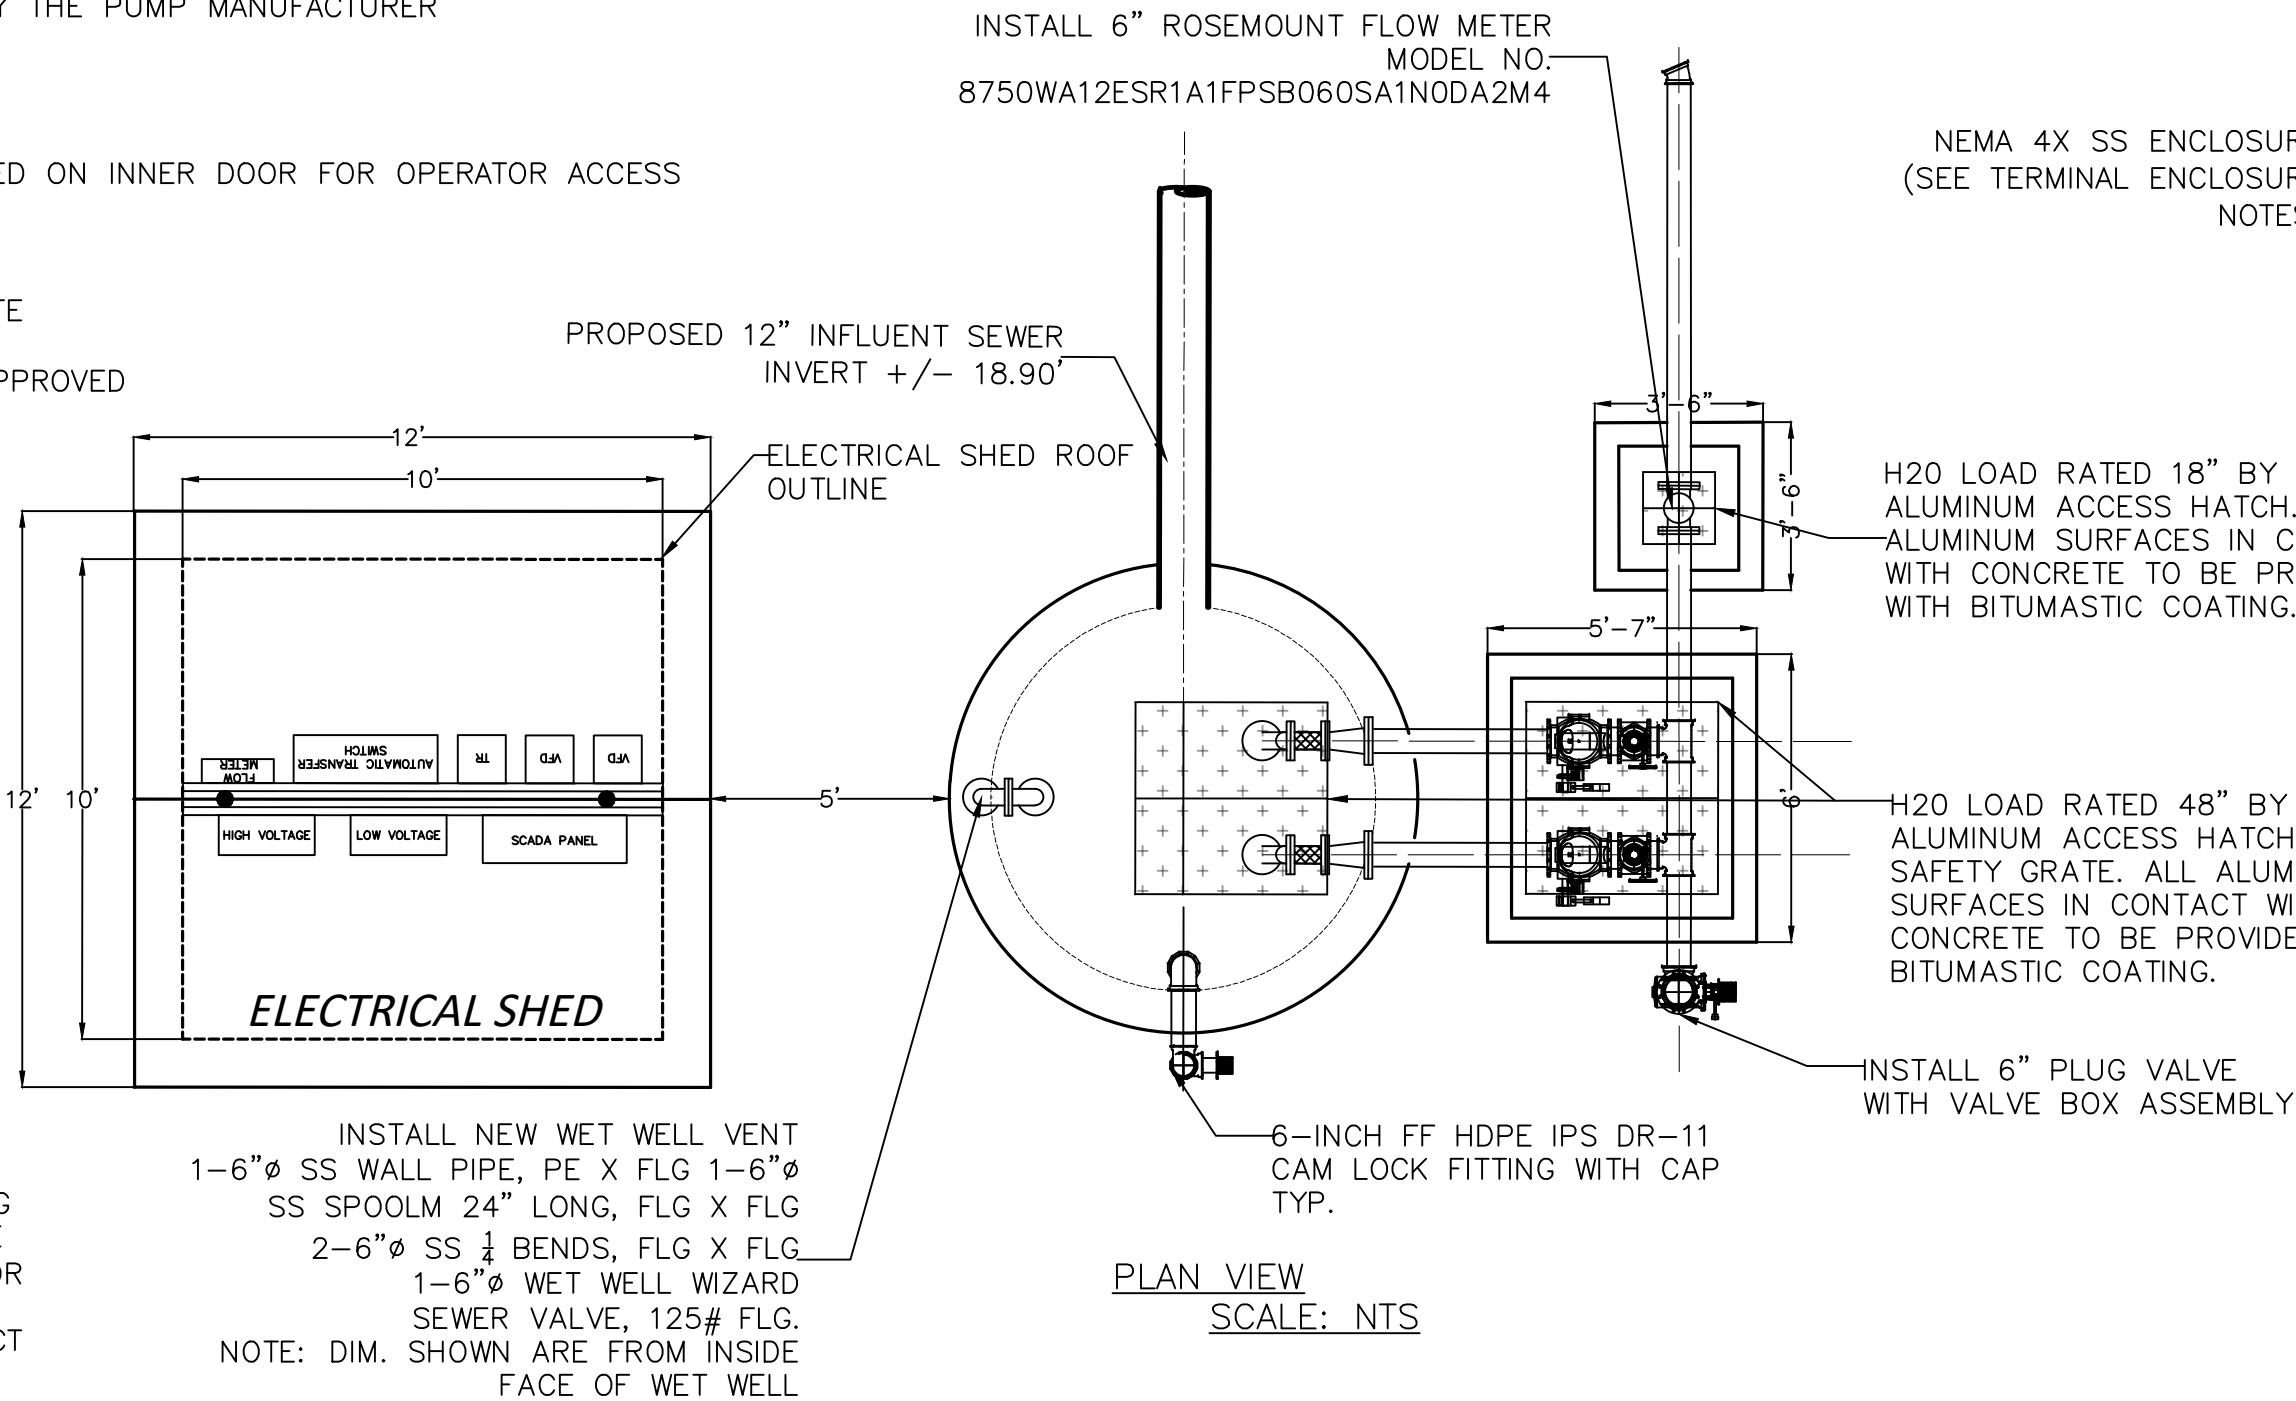

TERMINAL ENCLOSURE NOTES:

PROVIDE TERMINALS AS REQUIRED FOR POWER AND SIGNAL CABLE (FLOAT SWITCH) TERMINATIONS. PROVIDE 10% SPARE TERMINALS, MAKE CONNECTIONS PER PUMP MFR'S RECOMMENDATIONS. MAINTAIN 3' MIN. AC-DC SEPARATION IN TERMINAL ENCLOSURE. ROUTE CABLES VIA HOLES CORED IN COVER AND SEAL WATERTIGHT WITH WEATHERPROOF SILICONE SEALANT. VERIFY SEALANT/CABLE JACKET COMPATIBILITY.

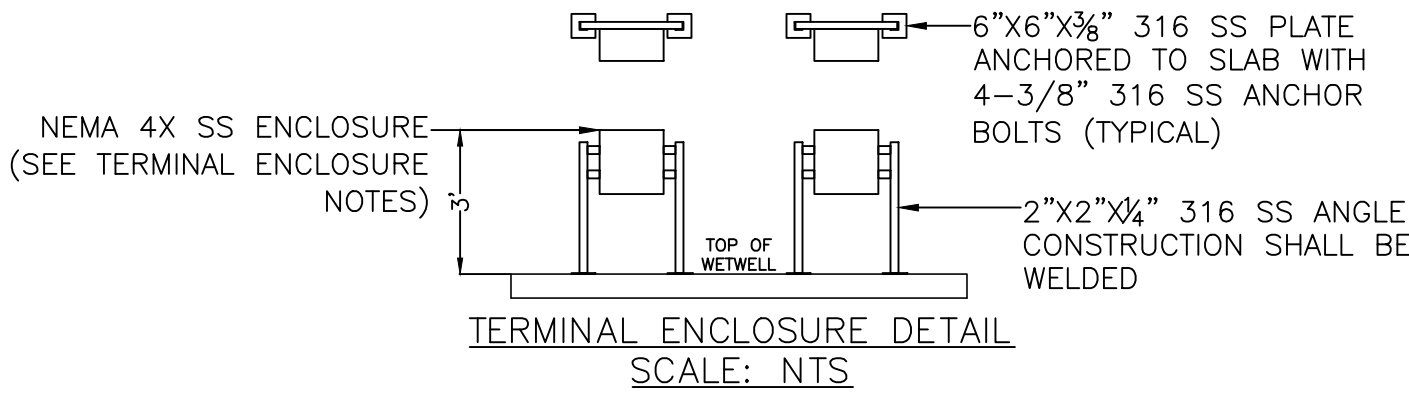


| DESCRIPTION  | INITIAL |
|--------------|---------|
| NO. OF PUMPS | 2       |
| PUMP (GPM)   | 200     |
| RPM          | 1700    |
| PHASE        | 3       |
| VOLTAGE      | 230     |
| HP           | 3       |
| DESIGN POINT | 18'     |

DUPLEX PUMP STATION  
SCALE: NTS

6-INCH FF HDPE RISER IPS DR--11 (CONTRACTOR TO DETERMINE LENGTH) INSTALL CAM-LOK FITTING WITH CAP

(2) VARIABLE SPEED SUBMERSIBLE PUMPS BASIS OF DESIGN: EACH PUMP TO MEET A MIN. FLOW RATE OF 200 GPM PER PUMP MOTOR: 230 V, 3PH., 60HZ PUMP HP TO BE DETERMINED BY PUMP MANUFACTURER PROVIDE THE FOLLOWING WITH EACH PUMP: DISCHARGE CONNECTION, 304 SS GUIDE RAILS, 304 SS INTERMEDIATE GUIDE BAR BRACKETS, 304 SS UPPER GUIDE BAR BRACKET, 316 SS LIFTING CHAIN & 304 SS CABLE HOLDER, 50' EACH POWER & CONTROL CABLES, ANCHOR DISCHARGE CONNECTION TO WETWELL ACCORDING TO MANUFACTURER'S INSTRUCTIONS. ALL ANCHOR BOLTS AND FASTENERS TO BE STAINLESS STEEL SET IN EPOXY OR HYDRO REACTIVE URETHANE TYP. INSTALL UPPER GUIDE BRACKET ACCORDING TO MANUFACTURER'S REFERENCE LINE & INSTRUCTIONS WITH S.S. HARDWARE.

PUMPS TO BE INSTALLED PER MANUFACTURER'S SPACING REQUIREMENTS.

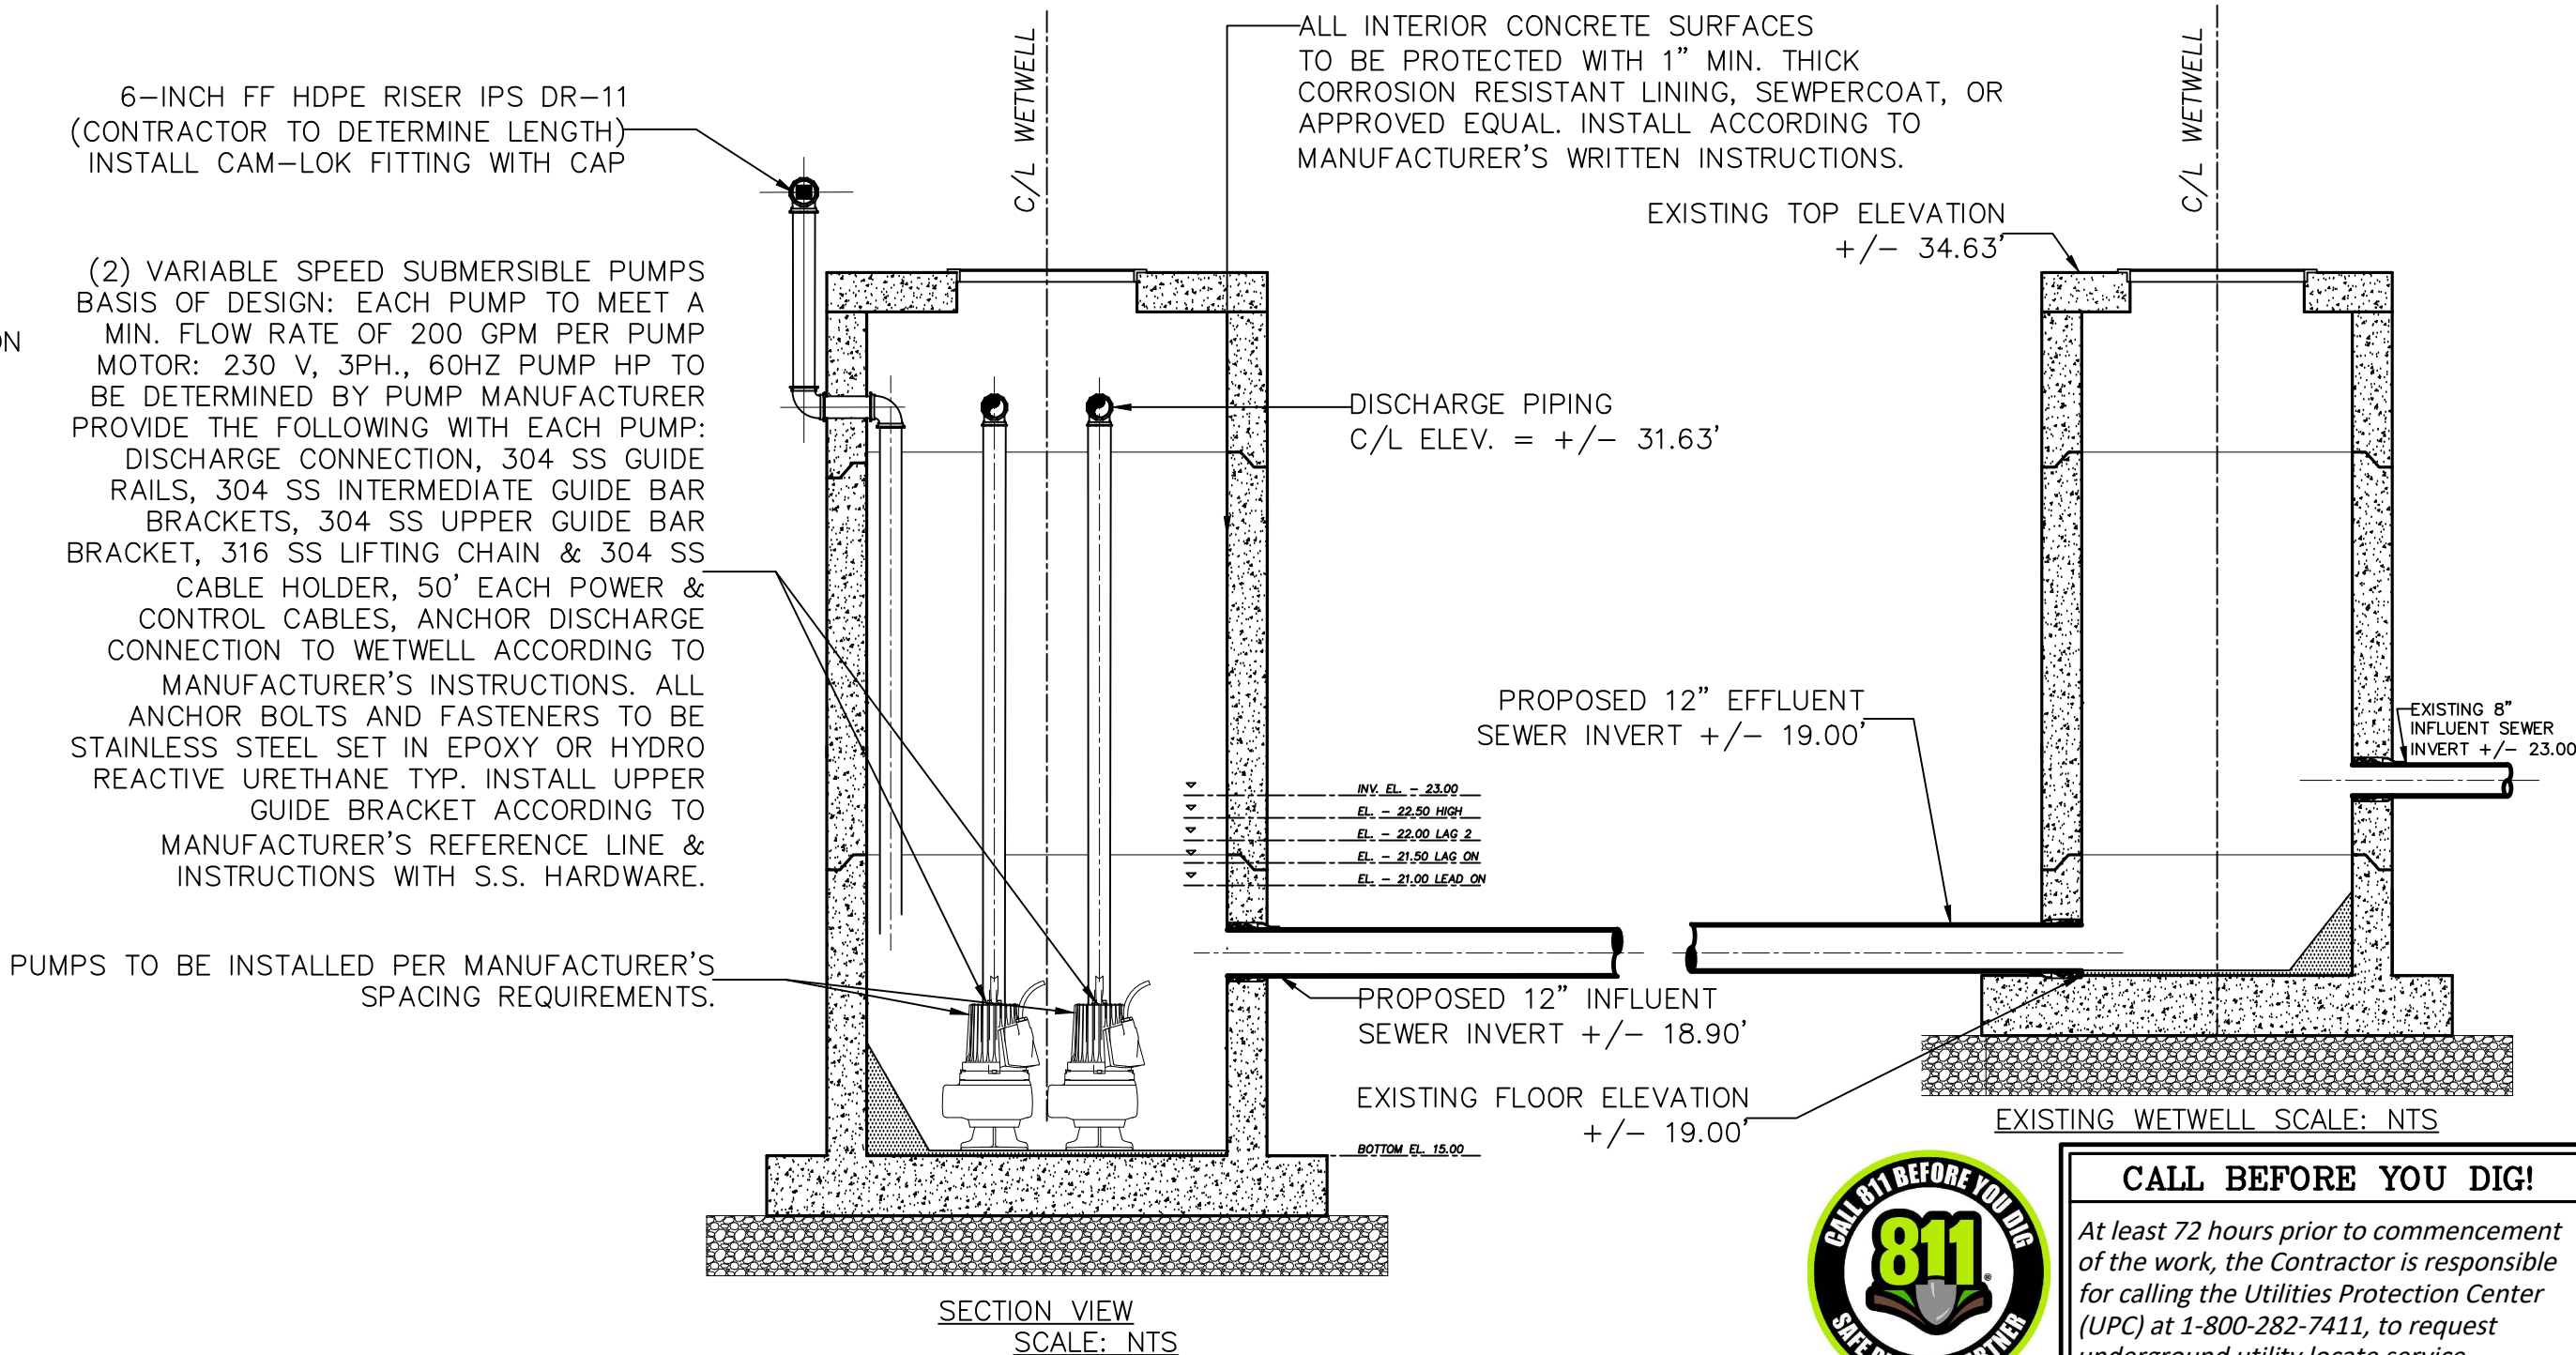




CONTRACTOR TO FIELD VERIFY ALL EXISTING DIMENSIONS & CONDITIONS PRIOR TO CONSTRUCTION OR FABRICATION. NOTIFY OWNER (JWSC) IMMEDIATELY IF CONFLICTS OR CHANGES ARISE.

CONCRETE NOTES:

CONCRETE SHALL BE OF NORMAL WEIGHT (150 PCF) AND SHALL DEVELOP A MINIMUM COMPREHENSIVE STRENGTH OF 4000 PSI AT 28 DAYS. (INCLUDE POLY FIBER MIX OF ¾lb. PER CU. YARD (MIN.)

CONCRETE FINISH TO BE NON--SLIP, BROOMED FINISH.

REINFORCING SHALL CONFORM WITH ASTM A615, GRADE 60, HAVING A MINIMUM YIELD STRENGTH OF 60 KSI.

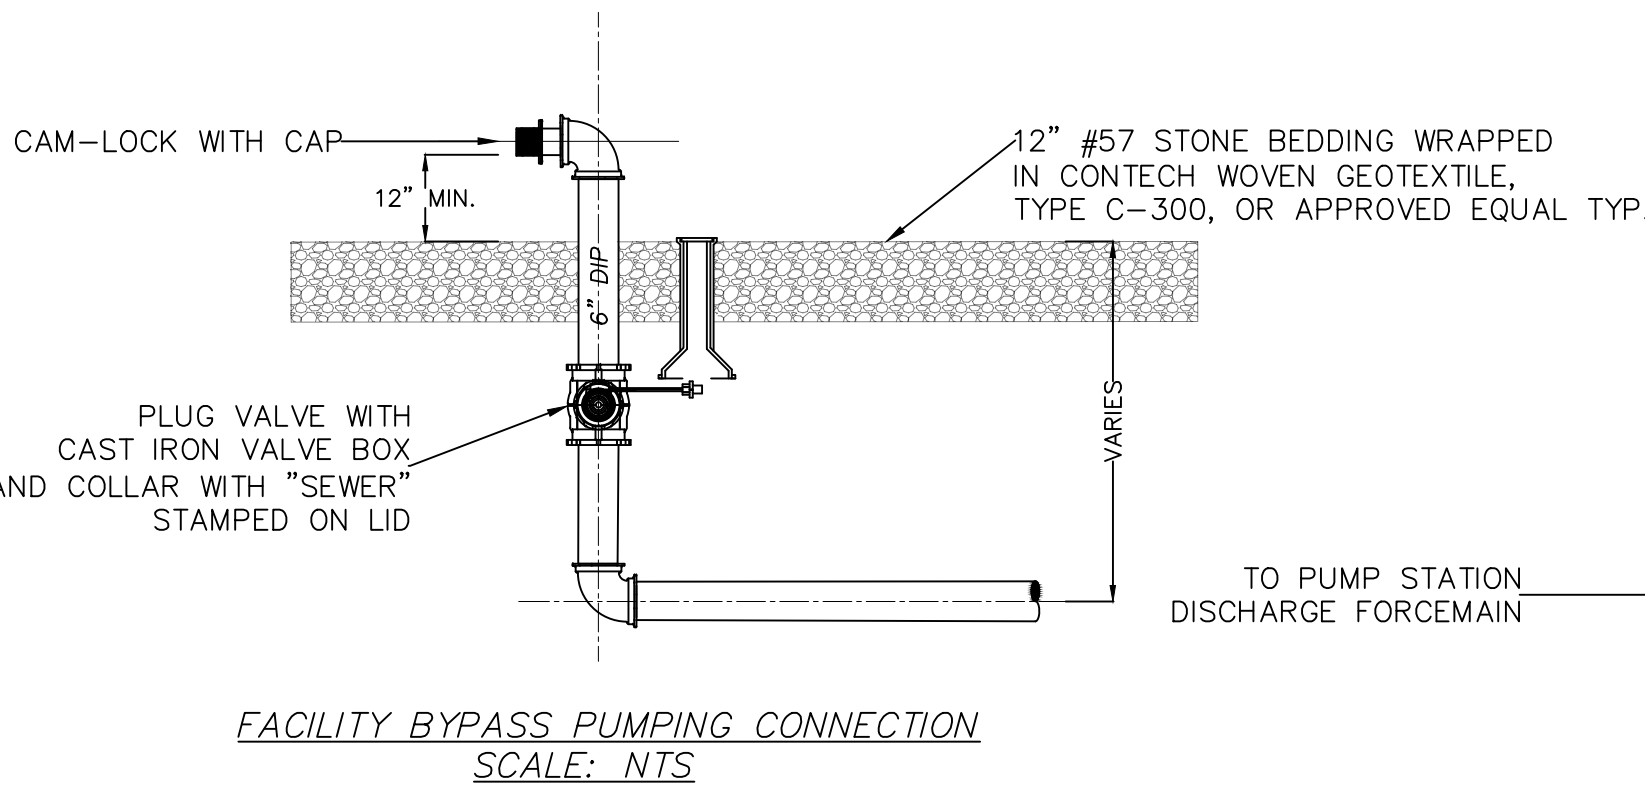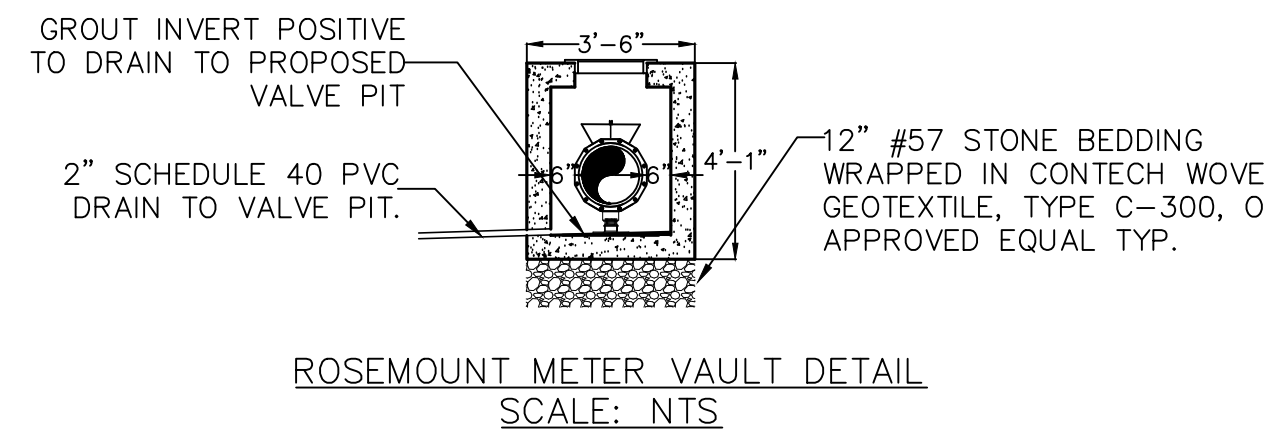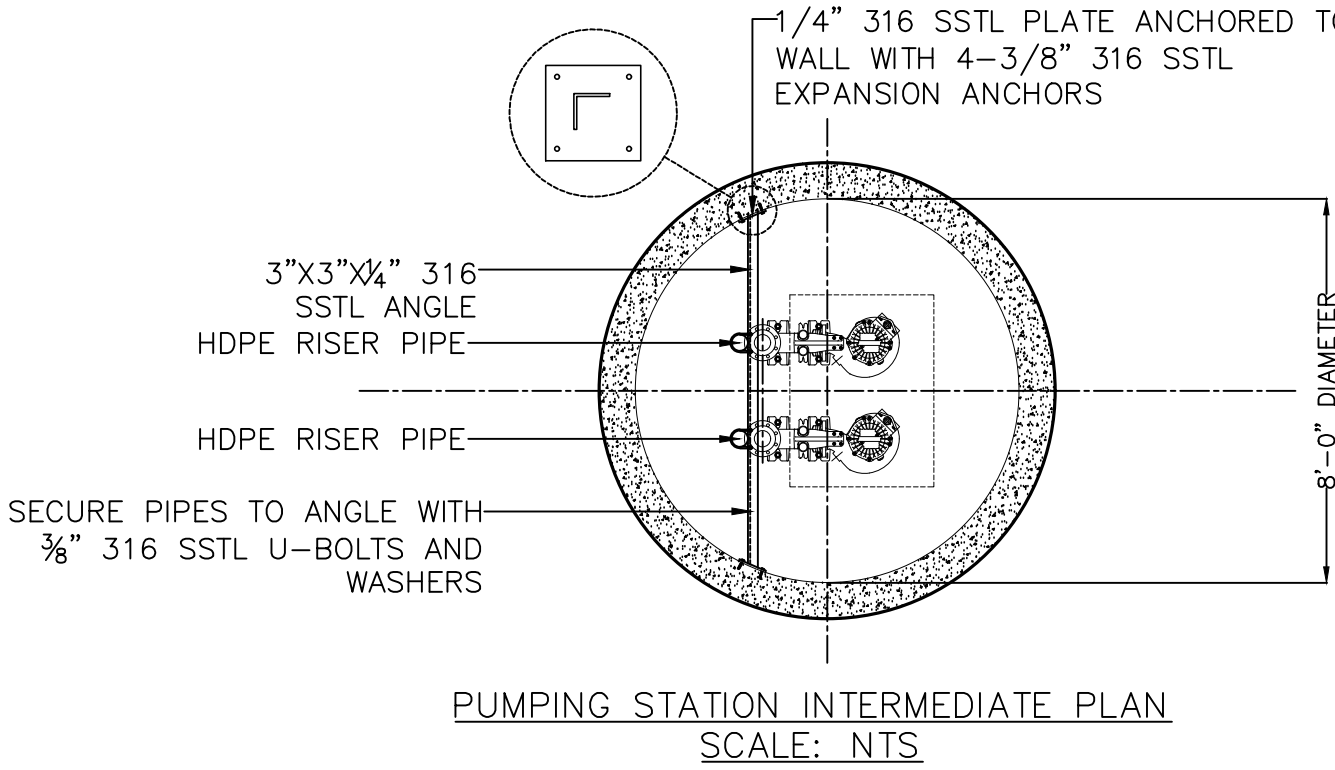

BRUNSWICK-GLYNN COUNTY  
JOINT WATER & SEWER COMMISSION  
PLANNING & CONSTRUCTION DIVISION  
1703 Gloucester Street  
Brunswick, Georgia 31520  
(912) 261-7110 Phone  
(912) 261-7178 Fax  
www.bjwsc.org



| NO.: | DATE: | COMMENTS: |
|------|-------|-----------|
| 1    | -     | -         |
| 2    | -     | -         |
| 3    | -     | -         |
| 4    | -     | -         |
| 5    | -     | -         |
| 6    | -     | -         |
| 7    | -     | -         |
| 8    | -     | -         |
| 9    | -     | -         |
| 10   | -     | -         |
| 11   | -     | -         |
| 12   | -     | -         |
| 99   | -     | -         |
| 100  | -     | -         |

PS4116  
REHABILITATION AND FM UPGRADE  
GLYNN COUNTY, GEORGIA  
BRUNSWICK-GLYNN COUNTY JOINT WATER & SEWER COMMISSION  
PROPOSED PLAN


|            |              |
|------------|--------------|
| FILE NO.:  | PS4116       |
| DATE:      | DEC 21, 2020 |
| SCALE:     | AS SHOWN     |
| DRAWN BY:  | HJP          |
| SHEET NO.: | P-4          |




**CALL BEFORE YOU DIG!**  
At least 72 hours prior to commencement of the work, the Contractor is responsible for calling the Utilities Protection Center (UPC) at 1-800-282-7411, to request underground utility locate service.

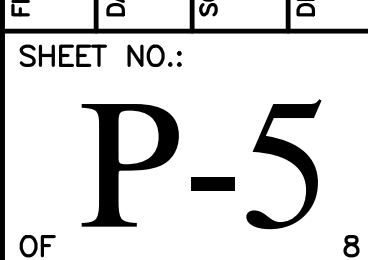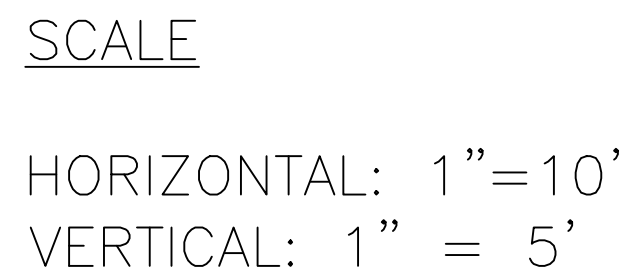




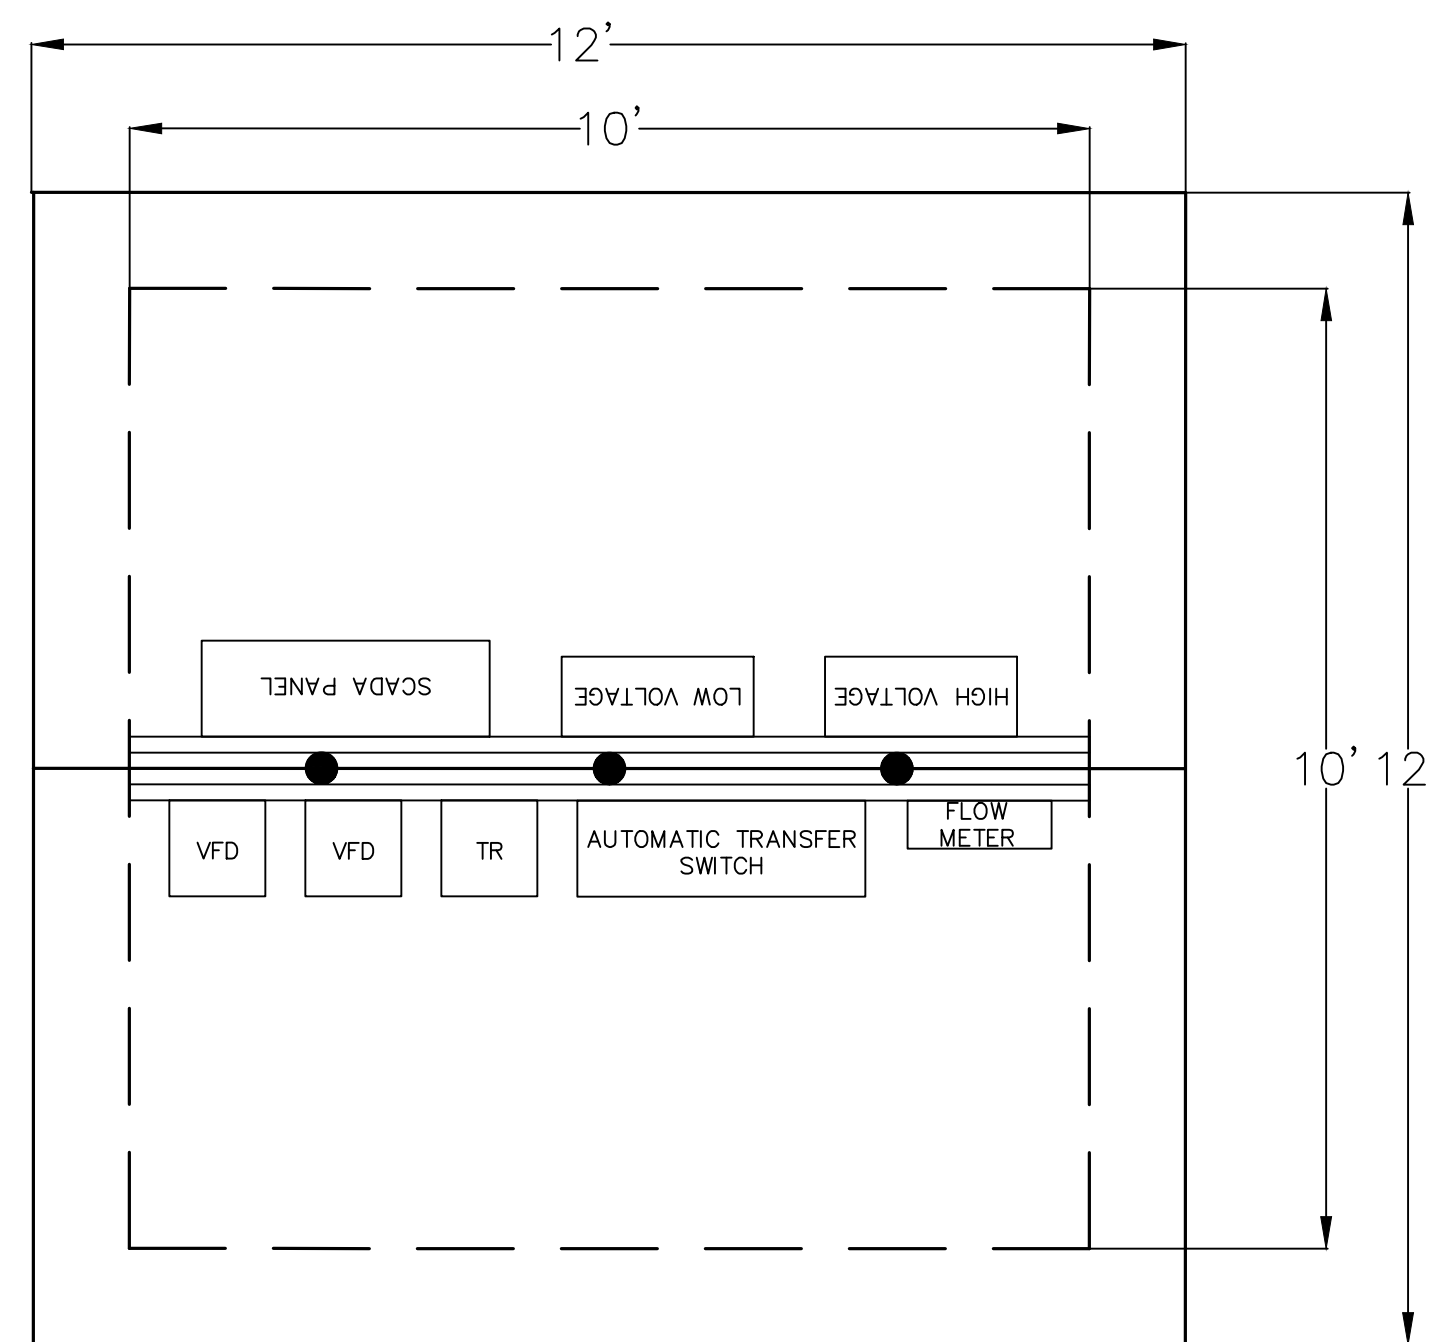


ELECTRICAL SHED PLAN VIEW

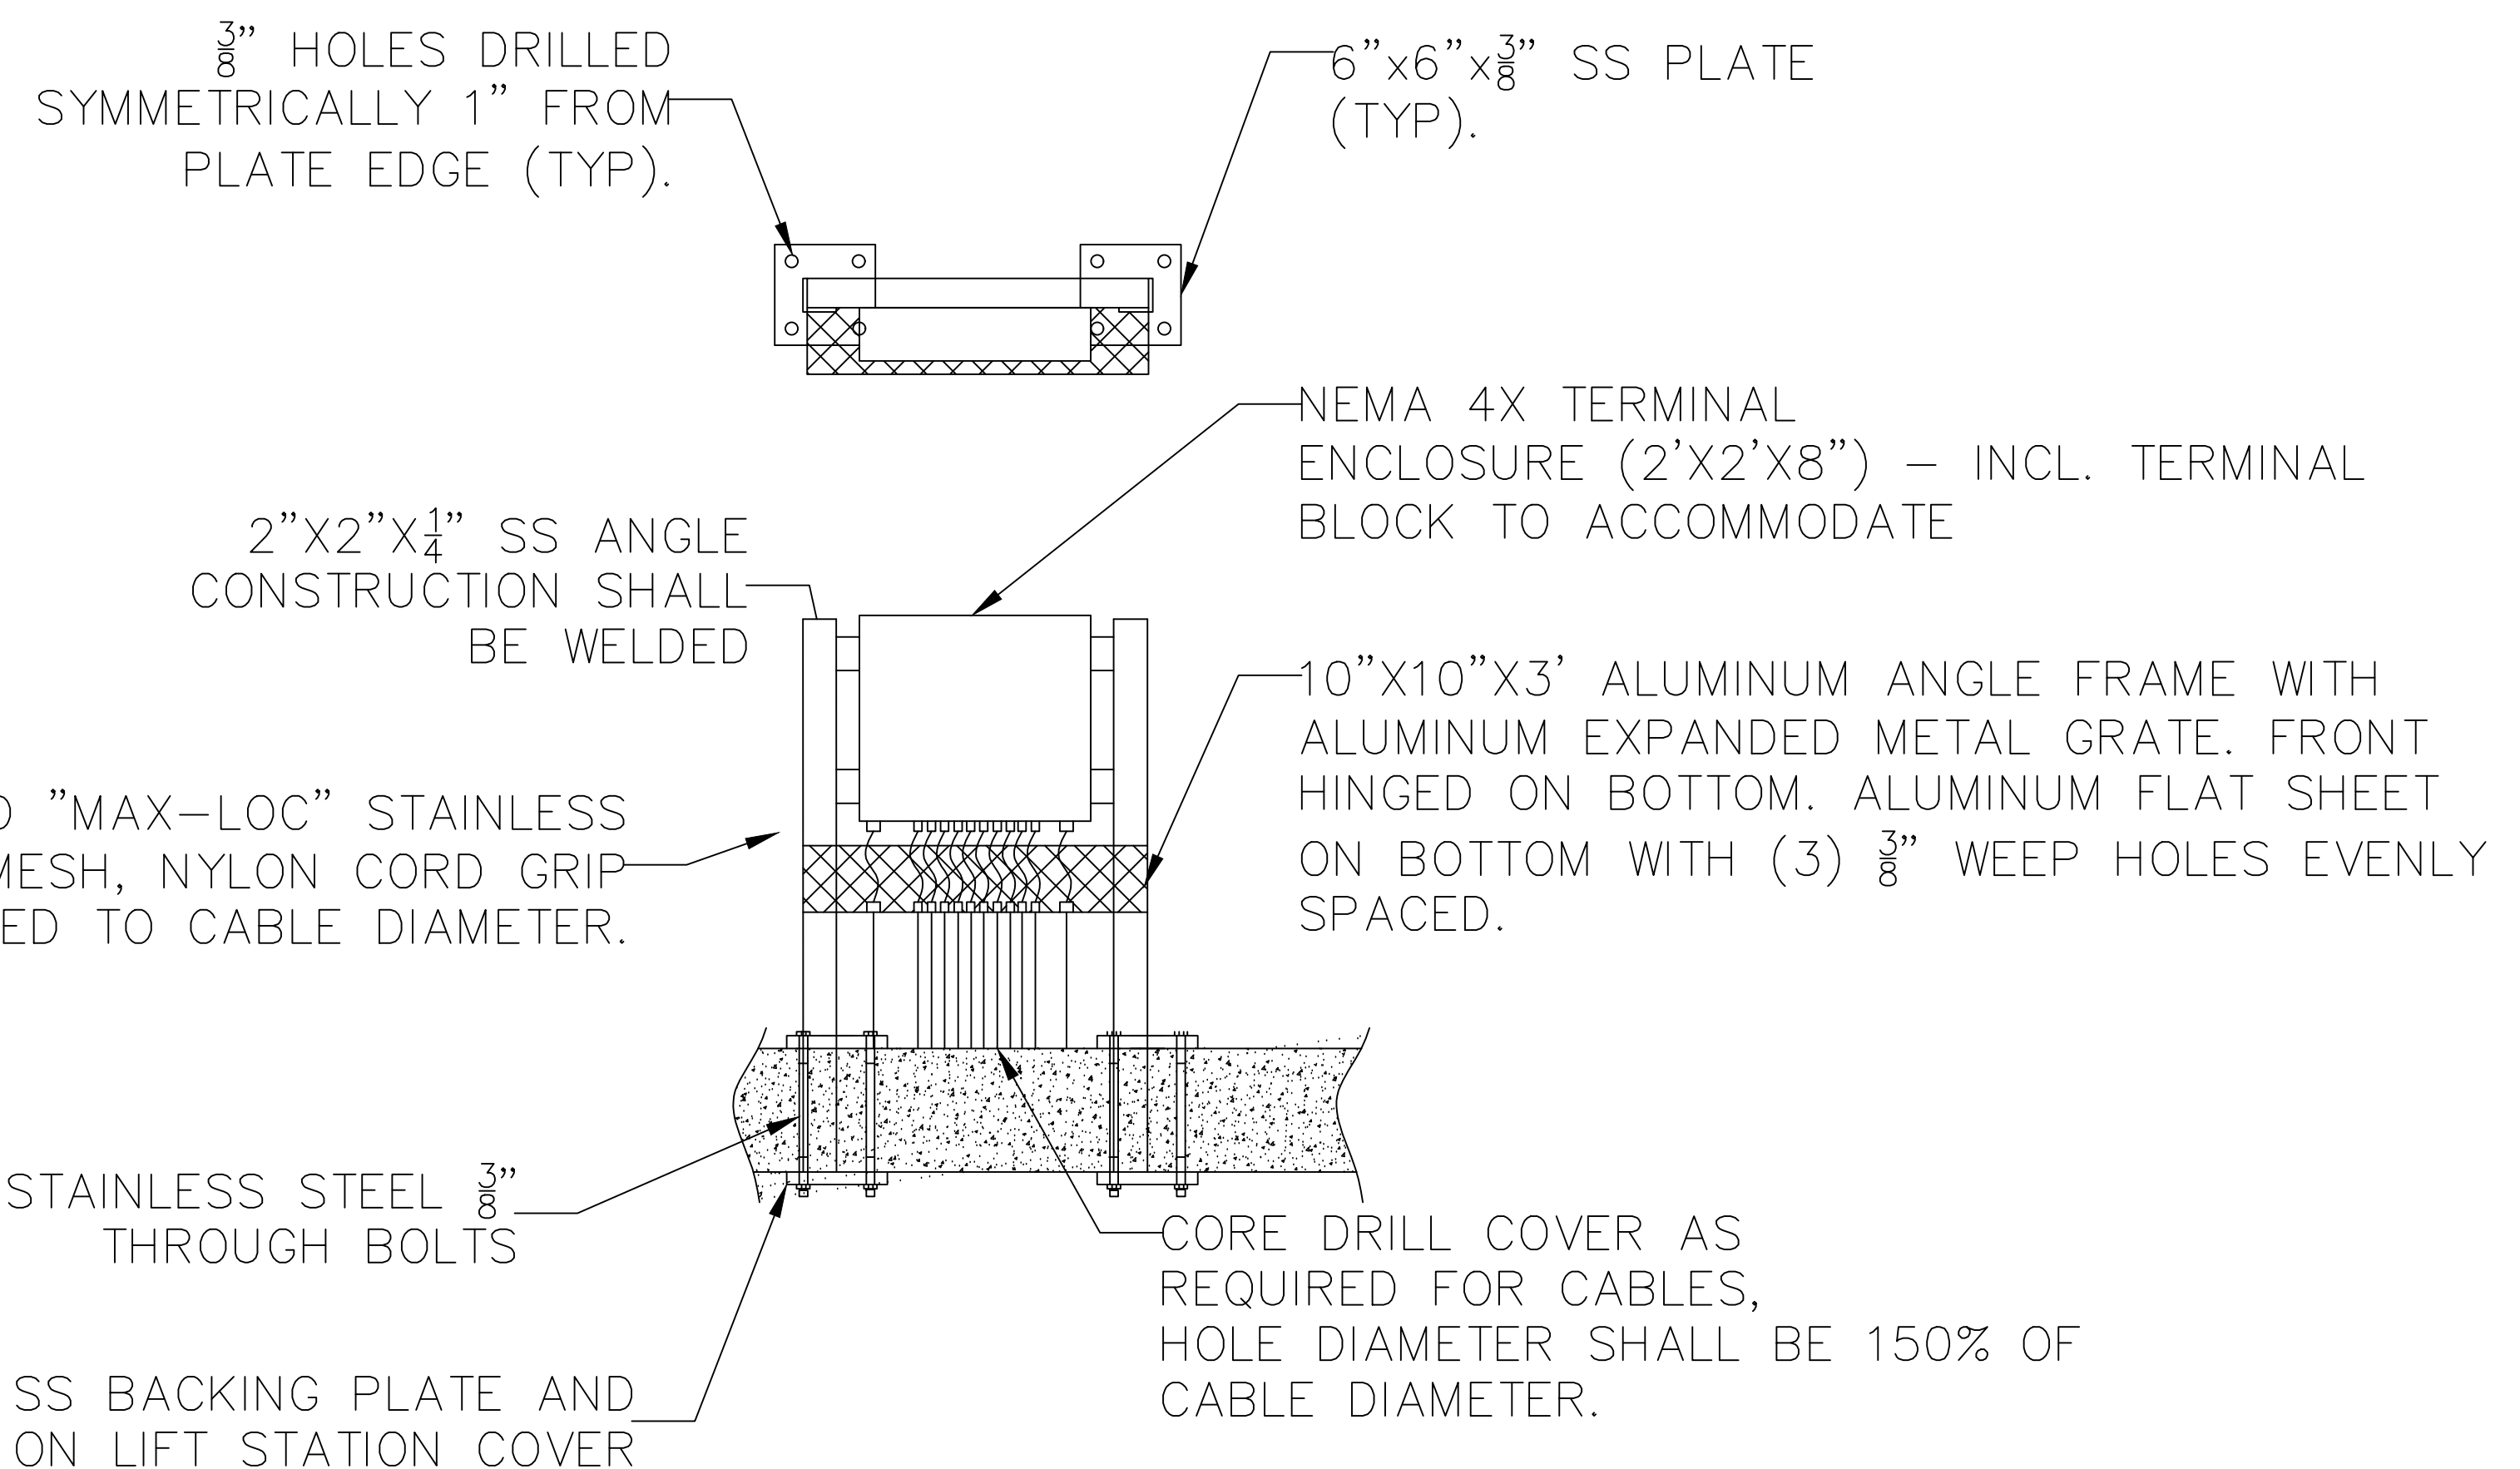

WETWELL LOW VOLTAGE MOUNTING DETAIL TYP.  
N.T.S.

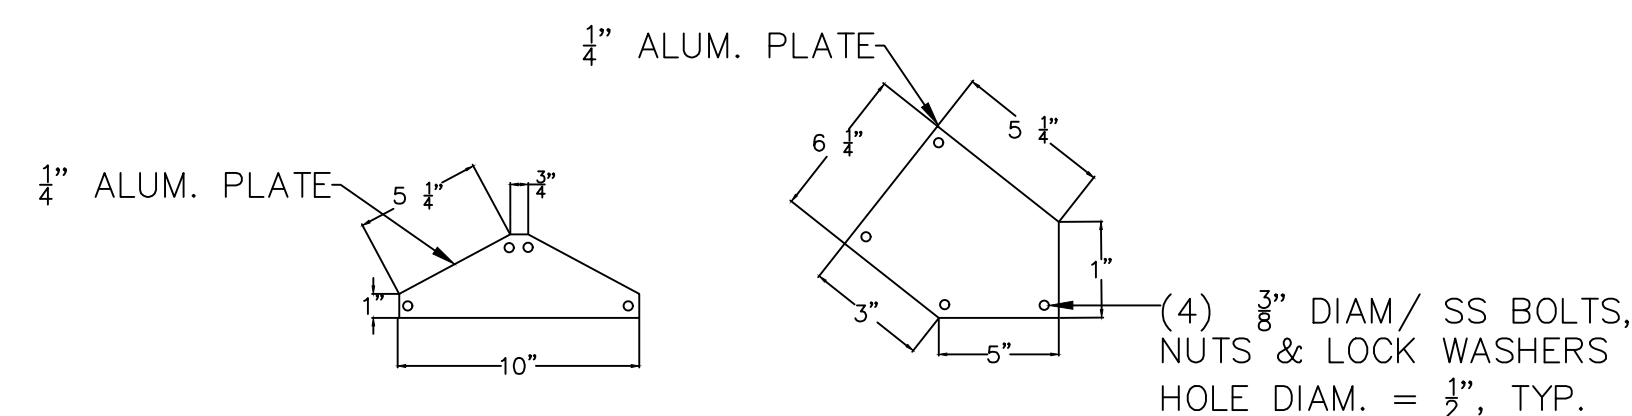


GUSSET PLATE DETAILS  
SCALE: N.T.S.

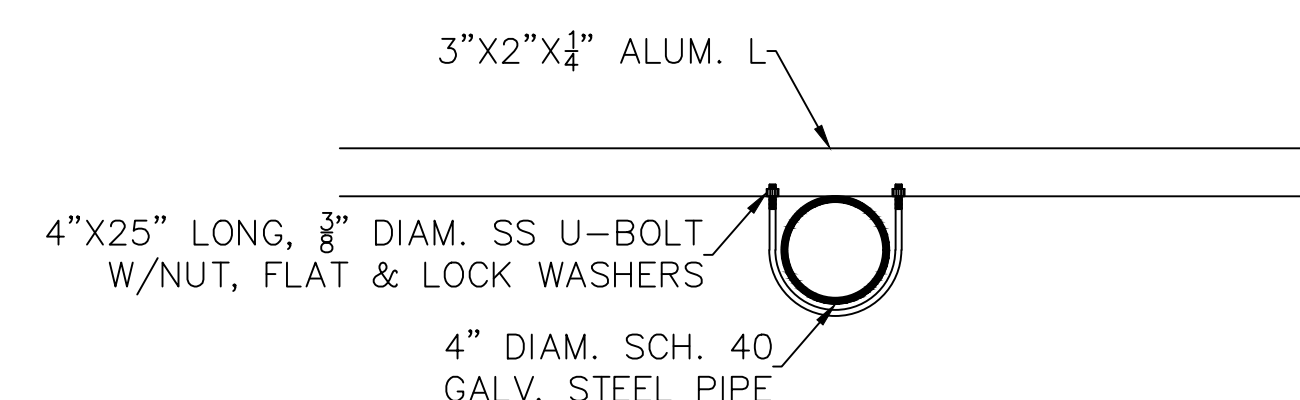


POST CONNECTION  
SCALE: N.T.S.

ALL ATTACHMENT HARDWARE SHALL BE 316 STAINLESS STEEL. FASTENERS SHALL BE GASKETED TYPE. ROOF TO BE WELDED ON TO ALUM. HAT CHANNEL.

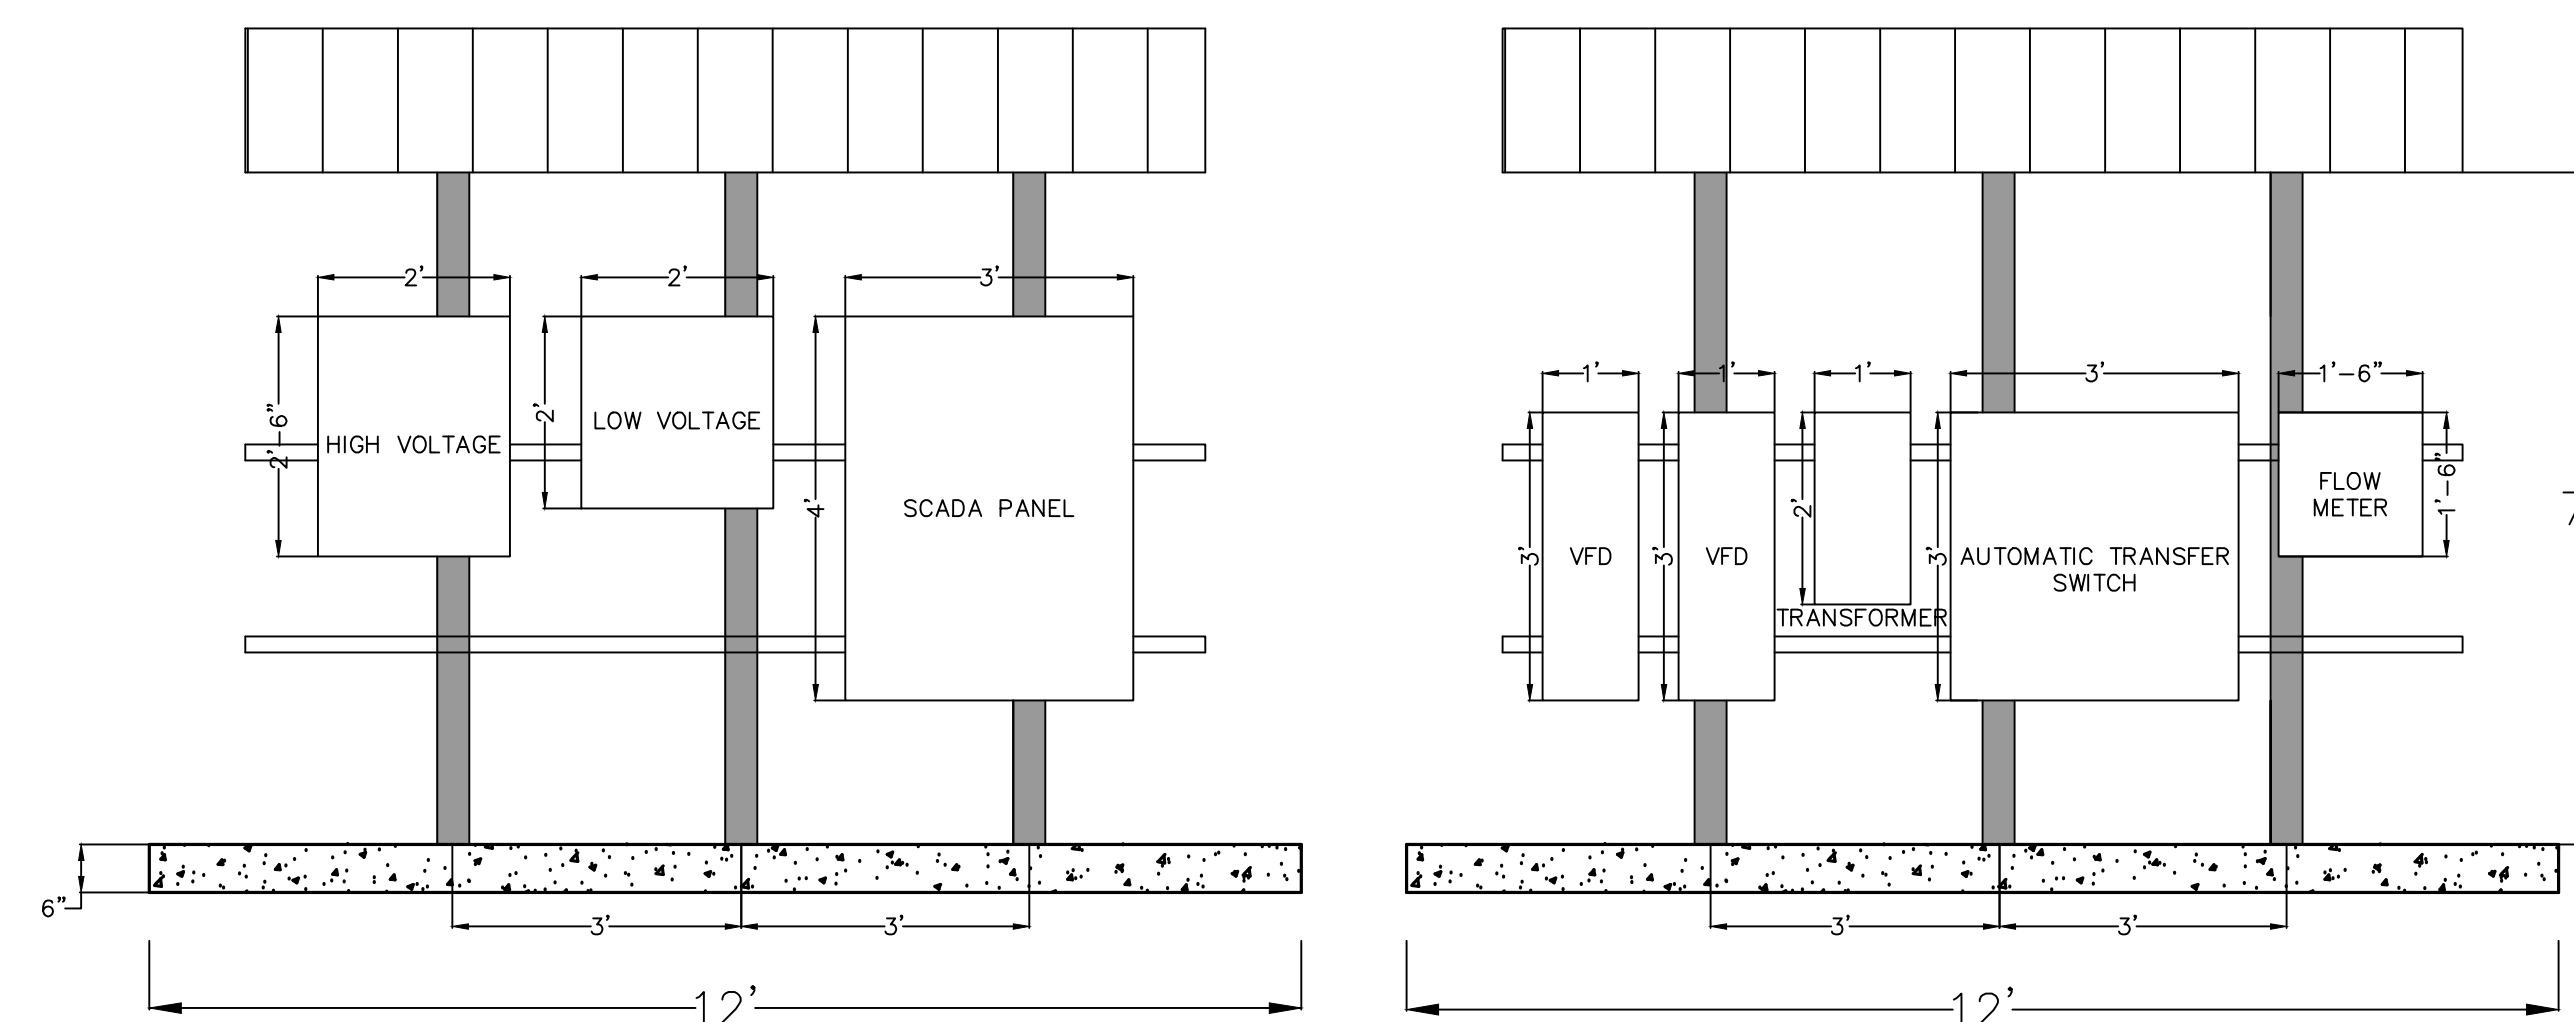

ELECTRICAL LAYOUT FRONT

ELECTRICAL LAYOUT BACK

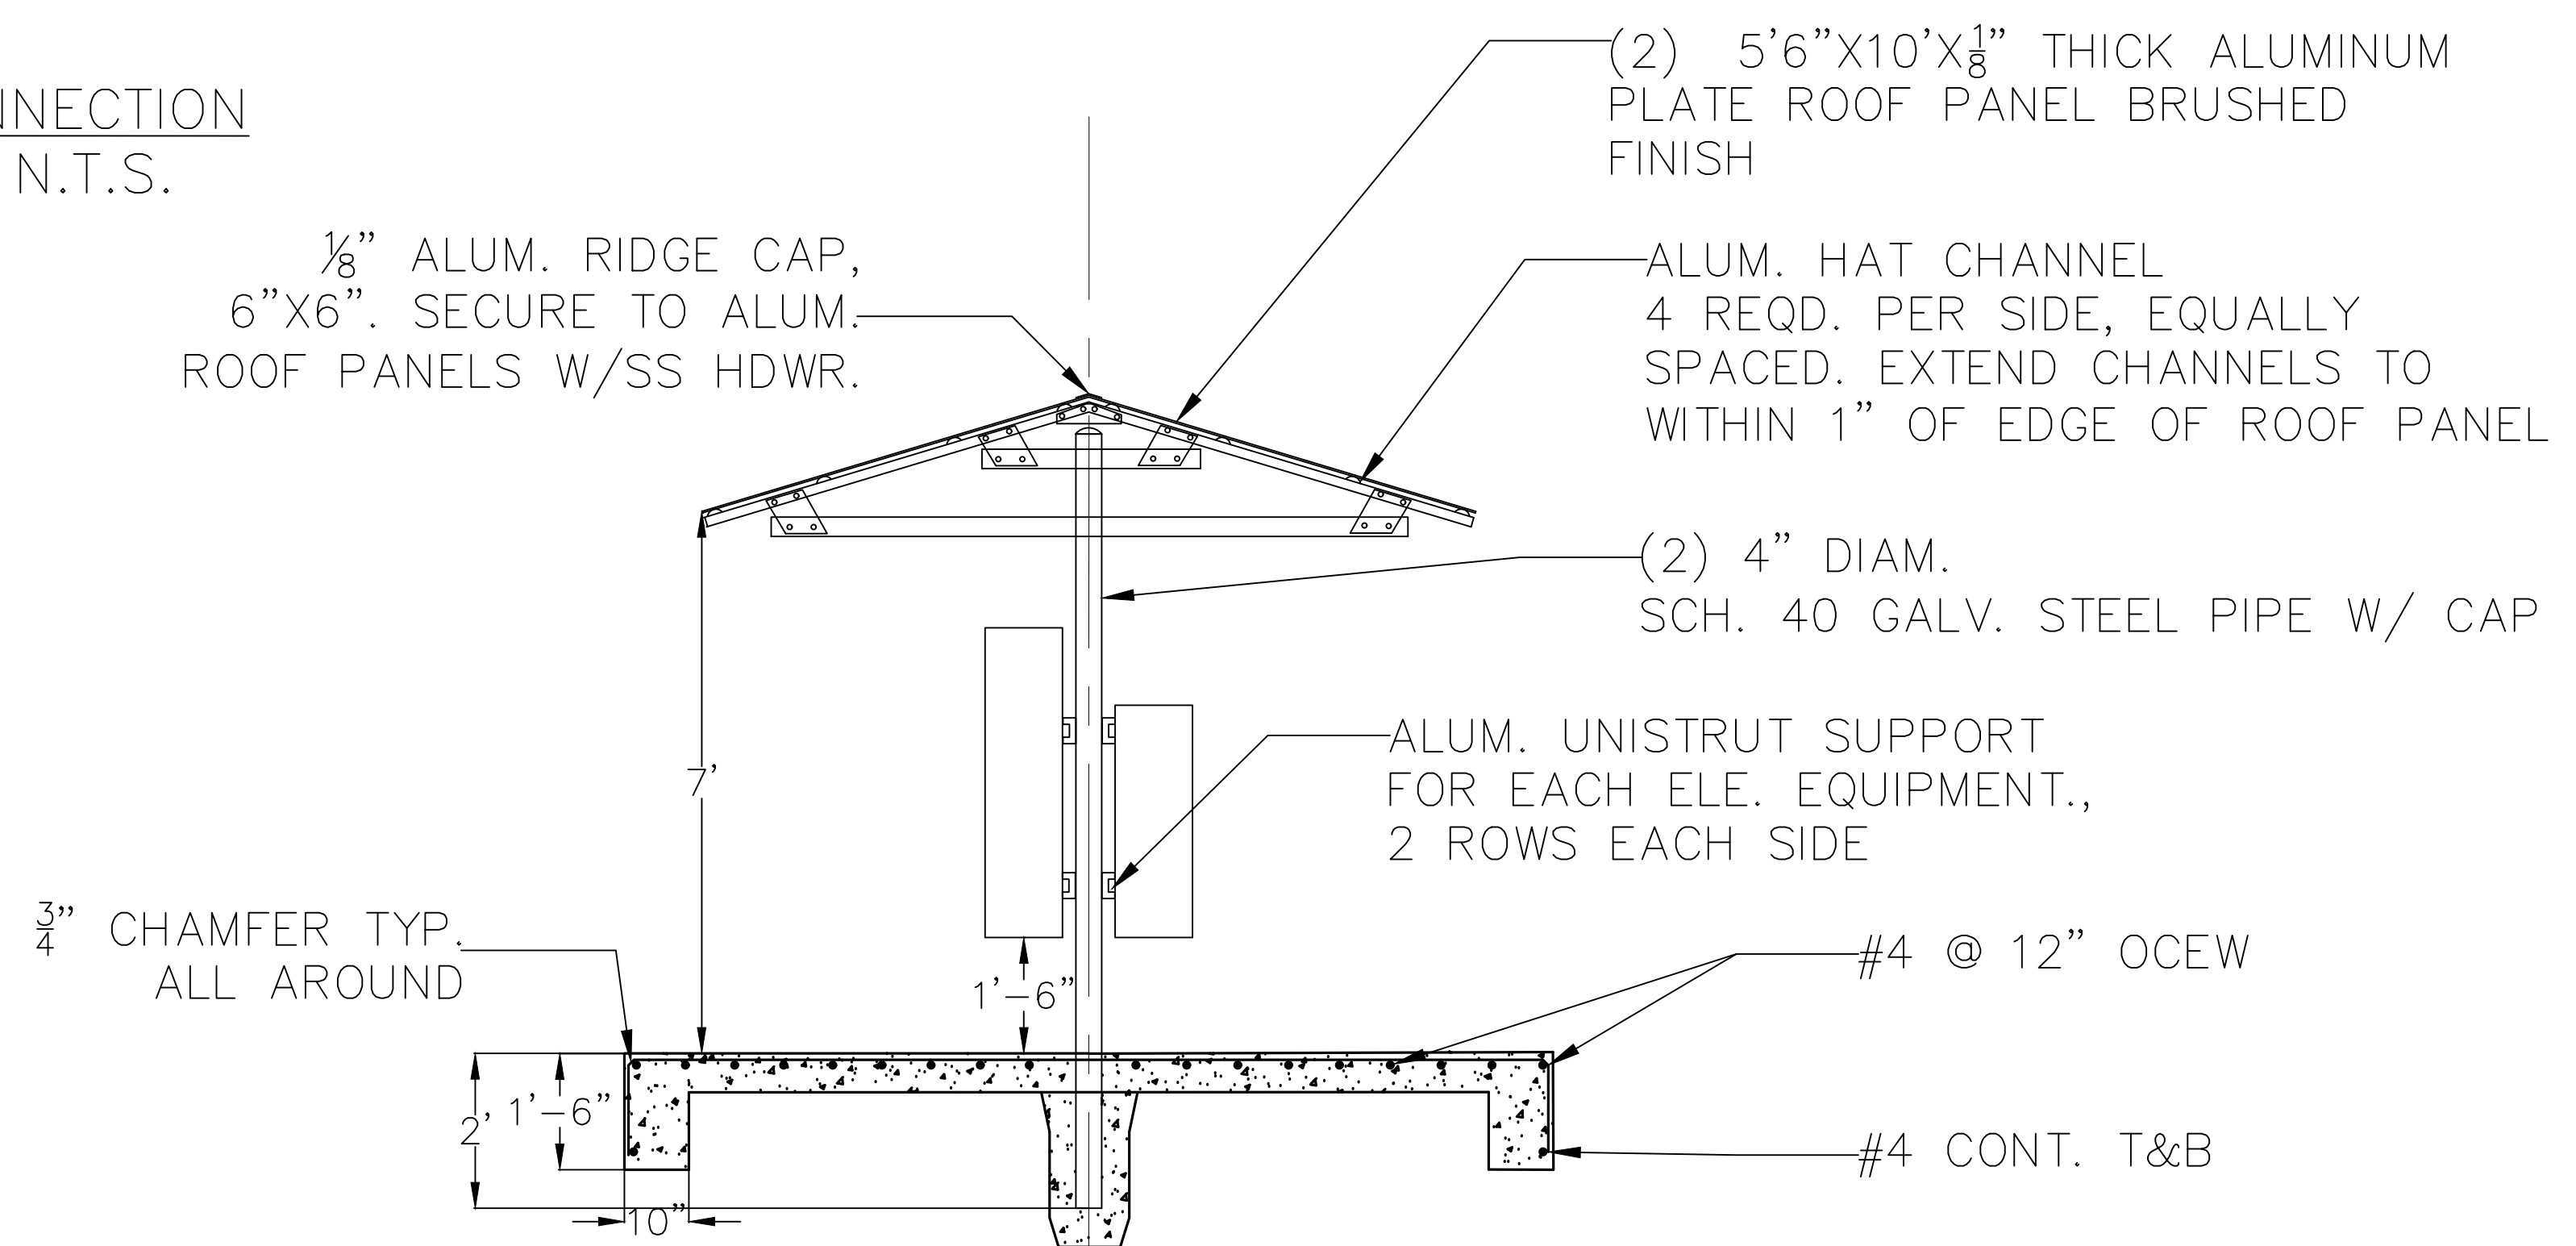

ELECTRICAL LAYOUT SIDE



BRUNSWICK-GLYNN COUNTY  
JOINT WATER & SEWER COMMISSION  
PLANNING & CONSTRUCTION DIVISION  
1703 Gloucester Street  
Brunswick, Georgia 31520  
(912) 261-7110 Phone  
(912) 261-7178 Fax  
www.bjwsc.org

| NO. | DATE | COMMENTS |
|-----|------|----------|
|     |      |          |
|     |      |          |
|     |      |          |
|     |      |          |



PS4116  
REHABILITATION AND FM UPGRADE  
GLYNN COUNTY, GEORGIA  
BRUNSWICK-GLYNN COUNTY JOINT WATER & SEWER COMMISSION

|                  |                    |                 |               |
|------------------|--------------------|-----------------|---------------|
| FILE NO.: PS4116 | DATE: DEC 21, 2020 | SCALE: AS SHOWN | DRAWN BY: HTP |
|------------------|--------------------|-----------------|---------------|

SHEET NO.:  
**P-7**  
OF 8



**CALL BEFORE YOU DIG!**  
At least 72 hours prior to commencement of the work, the Contractor is responsible for calling the Utilities Protection Center (UPC) at 1-800-282-7411, to request underground utility locate service.

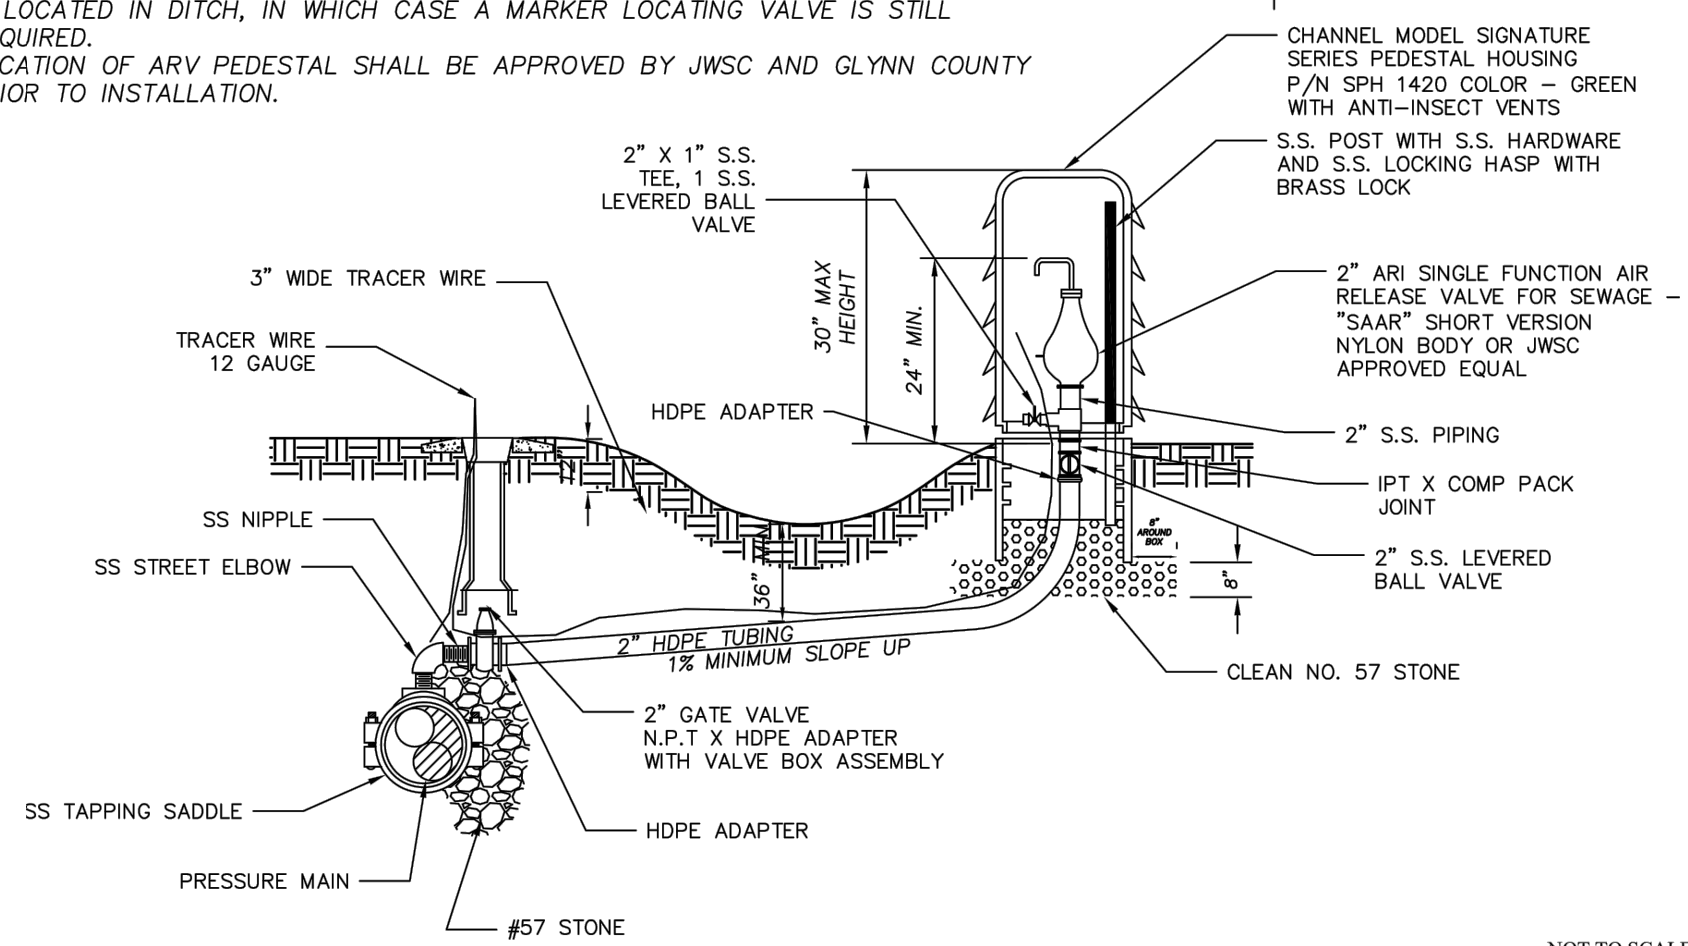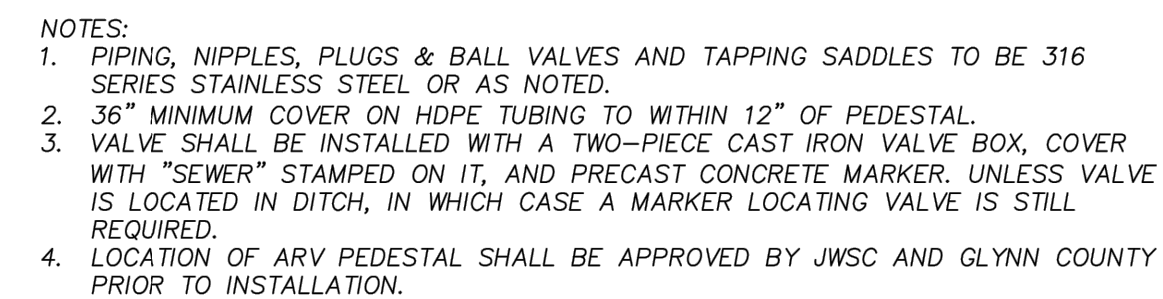



**BRUNSWICK-GLYNN COUNTY  
JOINT WATER & SEWER  
COMMISSION**

703 Gloucester Street Phone: (912) 261-7  
Brunswick, Georgia 31520 Fax: (912) 261-7  
Website: [www.bgjwsc.org](http://www.bgjwsc.org)

## SEWER AIR RELEASE VALVE PEDESTAL ASSEMBLY DETAIL

JWSC STANDARD DETAIL 4-4A

Date: JANUARY 2017

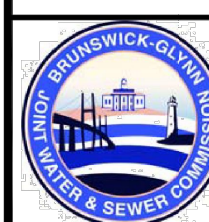
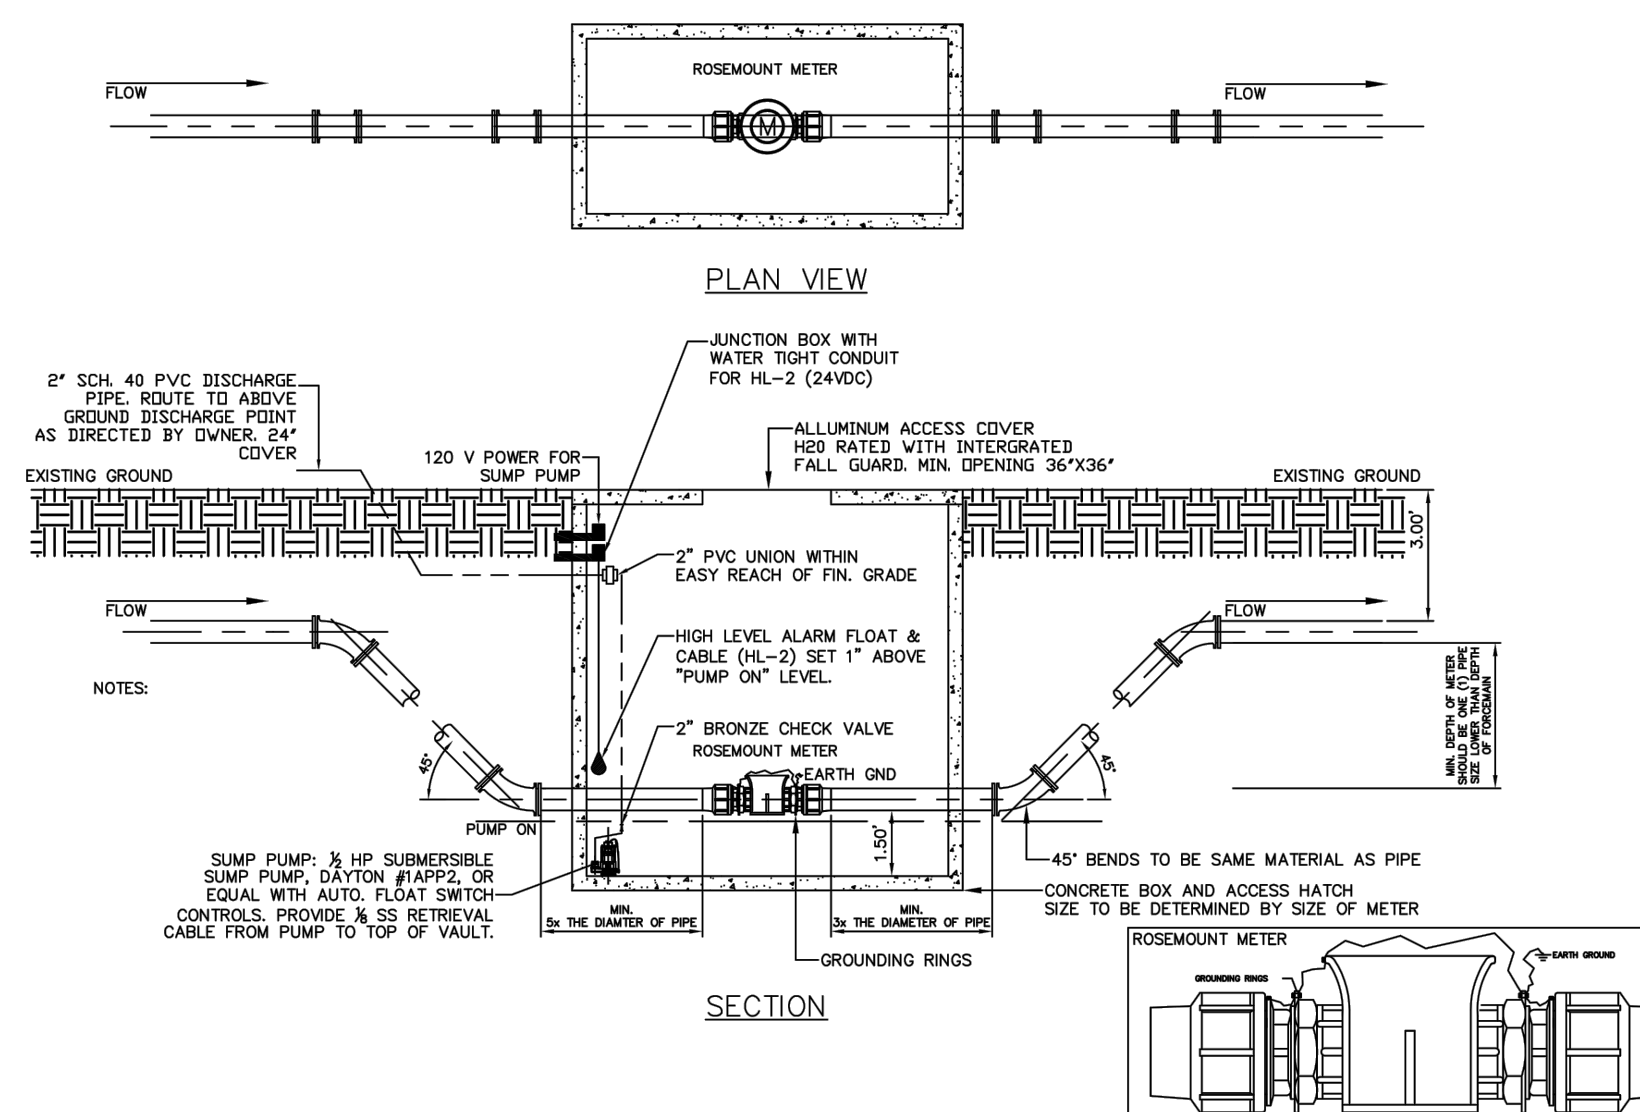


BRUNSWICK-GLYNN COUNTY  
JOINT WATER & SEWER  
COMMISSION

### ROSEMOUNT METER DETAIL

JWSC STANDARD DETAIL 4-9

Date: JUNE 2018

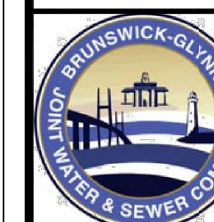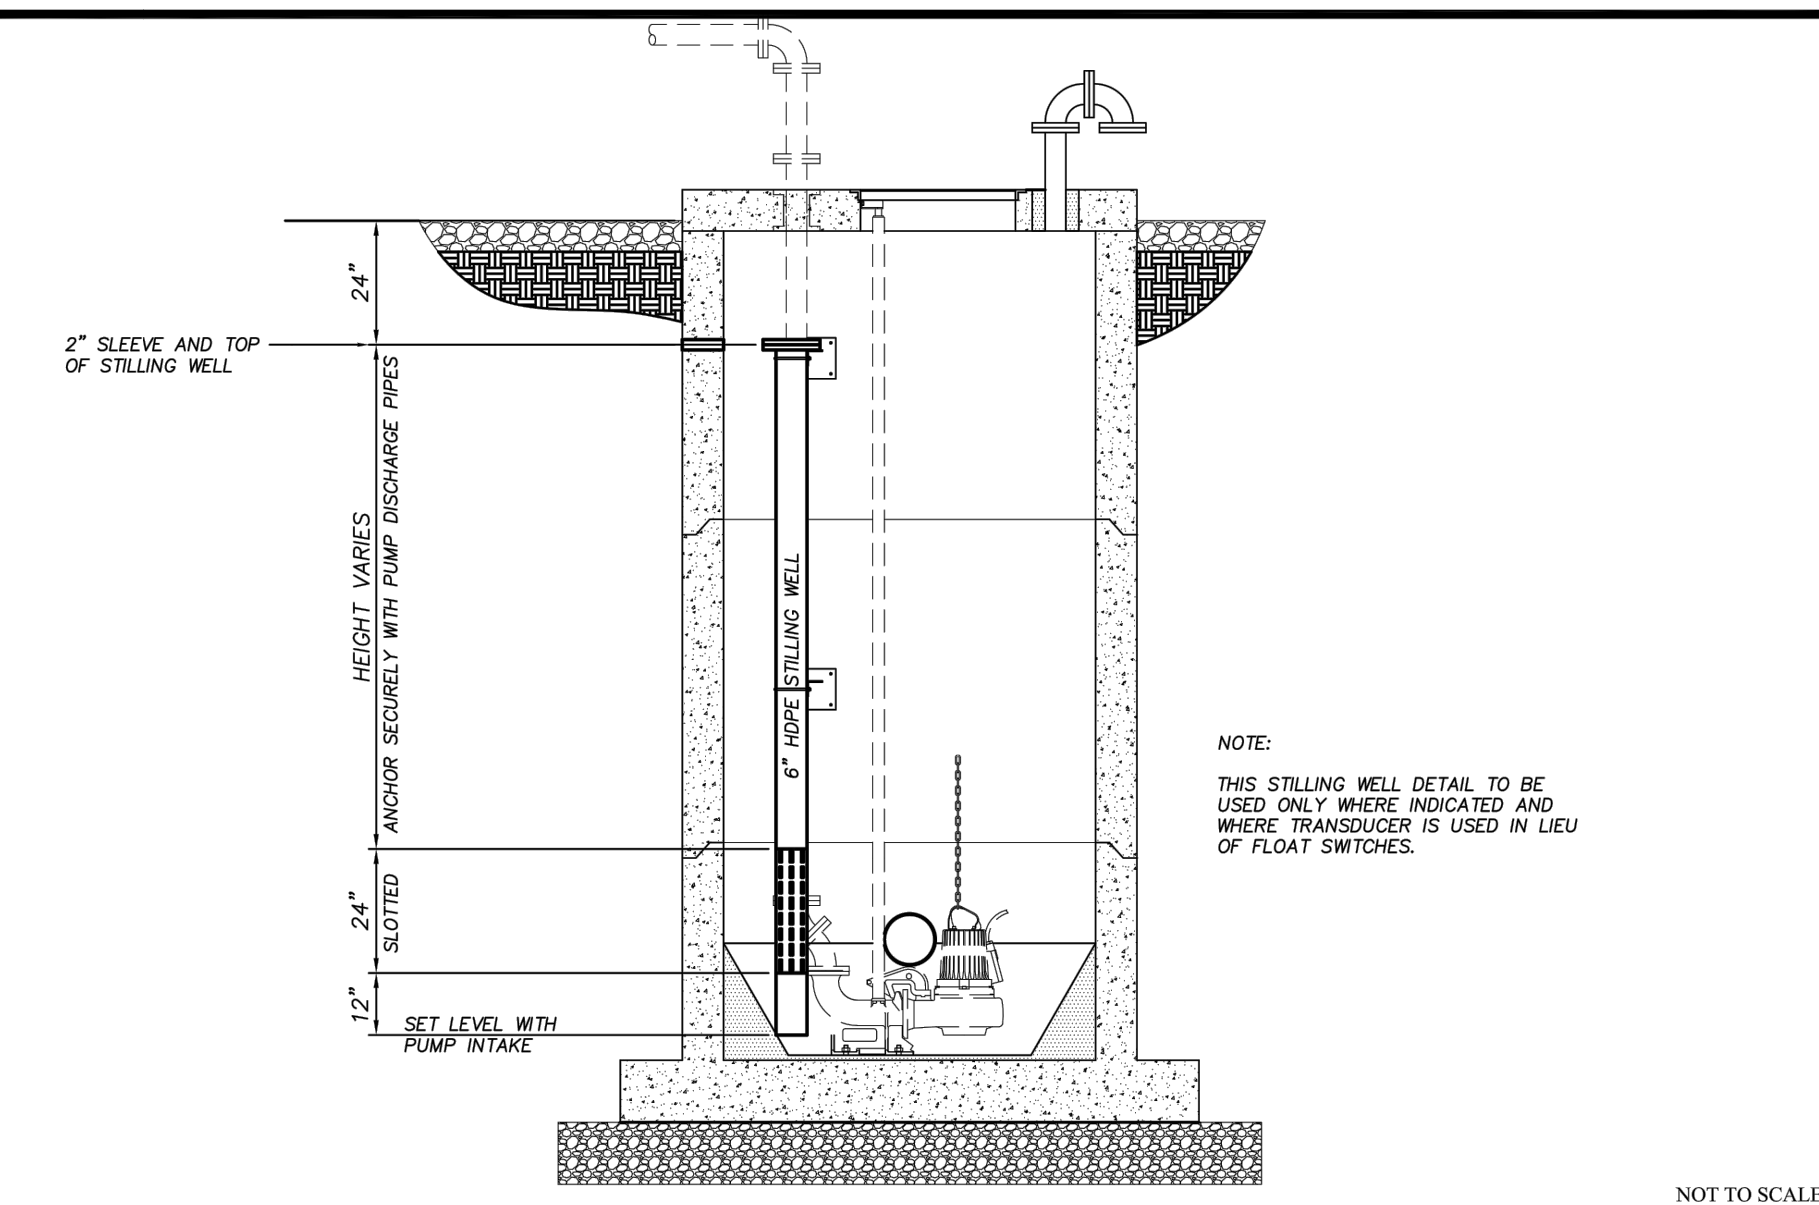


**BRUNSWICK-GLYNN COUNTY  
JOINT WATER & SEWER  
COMMISSION**

700 Gloucester Street, Suite 300 Phone: (912) 261-7110  
Brunswick, Georgia 31520 Fax: (912) 261-7178  
Website: [www.bgjwsc.org](http://www.bgjwsc.org)

## TRANSDUCER STILLING WELL

JWSC STANDARD DETAIL 4-5

Date: OCTOBER 2011

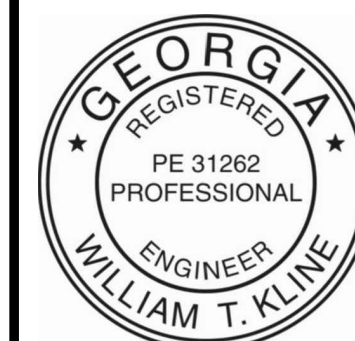

**BRUNSWICK-GLYNN COUNTY  
JOINT WATER & SEWER COMMISSION  
PLANNING & CONSTRUCTION DIVISION**

1703 Gloucester Street  
Brunswick, Georgia 31520  
(912) 261-7110 Phone  
(912) 261-7178 Fax  
[www.bgjwsc.org](http://www.bgjwsc.org)

[illegible]

## REVISIONS

PS4116  
REHABILITATION AND FM UPGRADE  
GLYNN COUNTY, GEORGIA  
IBRUNSWICK-GLYNN COUNTY JOINT WATER & SEWER COMMISSION  
JWSC DETAILS

|                  |              |
|------------------|--------------|
| <b>FILE NO.:</b> | PS4116       |
| <b>DATE:</b>     | DEC 21, 2020 |
| <b>SCALE:</b>    | AS SHOWN     |
| <b>DRAWN BY:</b> | HP           |

SHEET NO.:

P-8

---



**CALL BEFORE YOU DIG!**  
At least 72 hours prior to commencement of the work, the Contractor is responsible for calling the Utilities Protection Center (UPC) at 1-800-282-7411, to request underground utility locate service.